



FILE NAME: I:\Projects\140009\Main\Wind_Mid_Form_LSA_Veg_CAD\CAD\140009_collection_index.dwg
 USER: Steven M. Meliott
 DATE: 7/27/11 PM

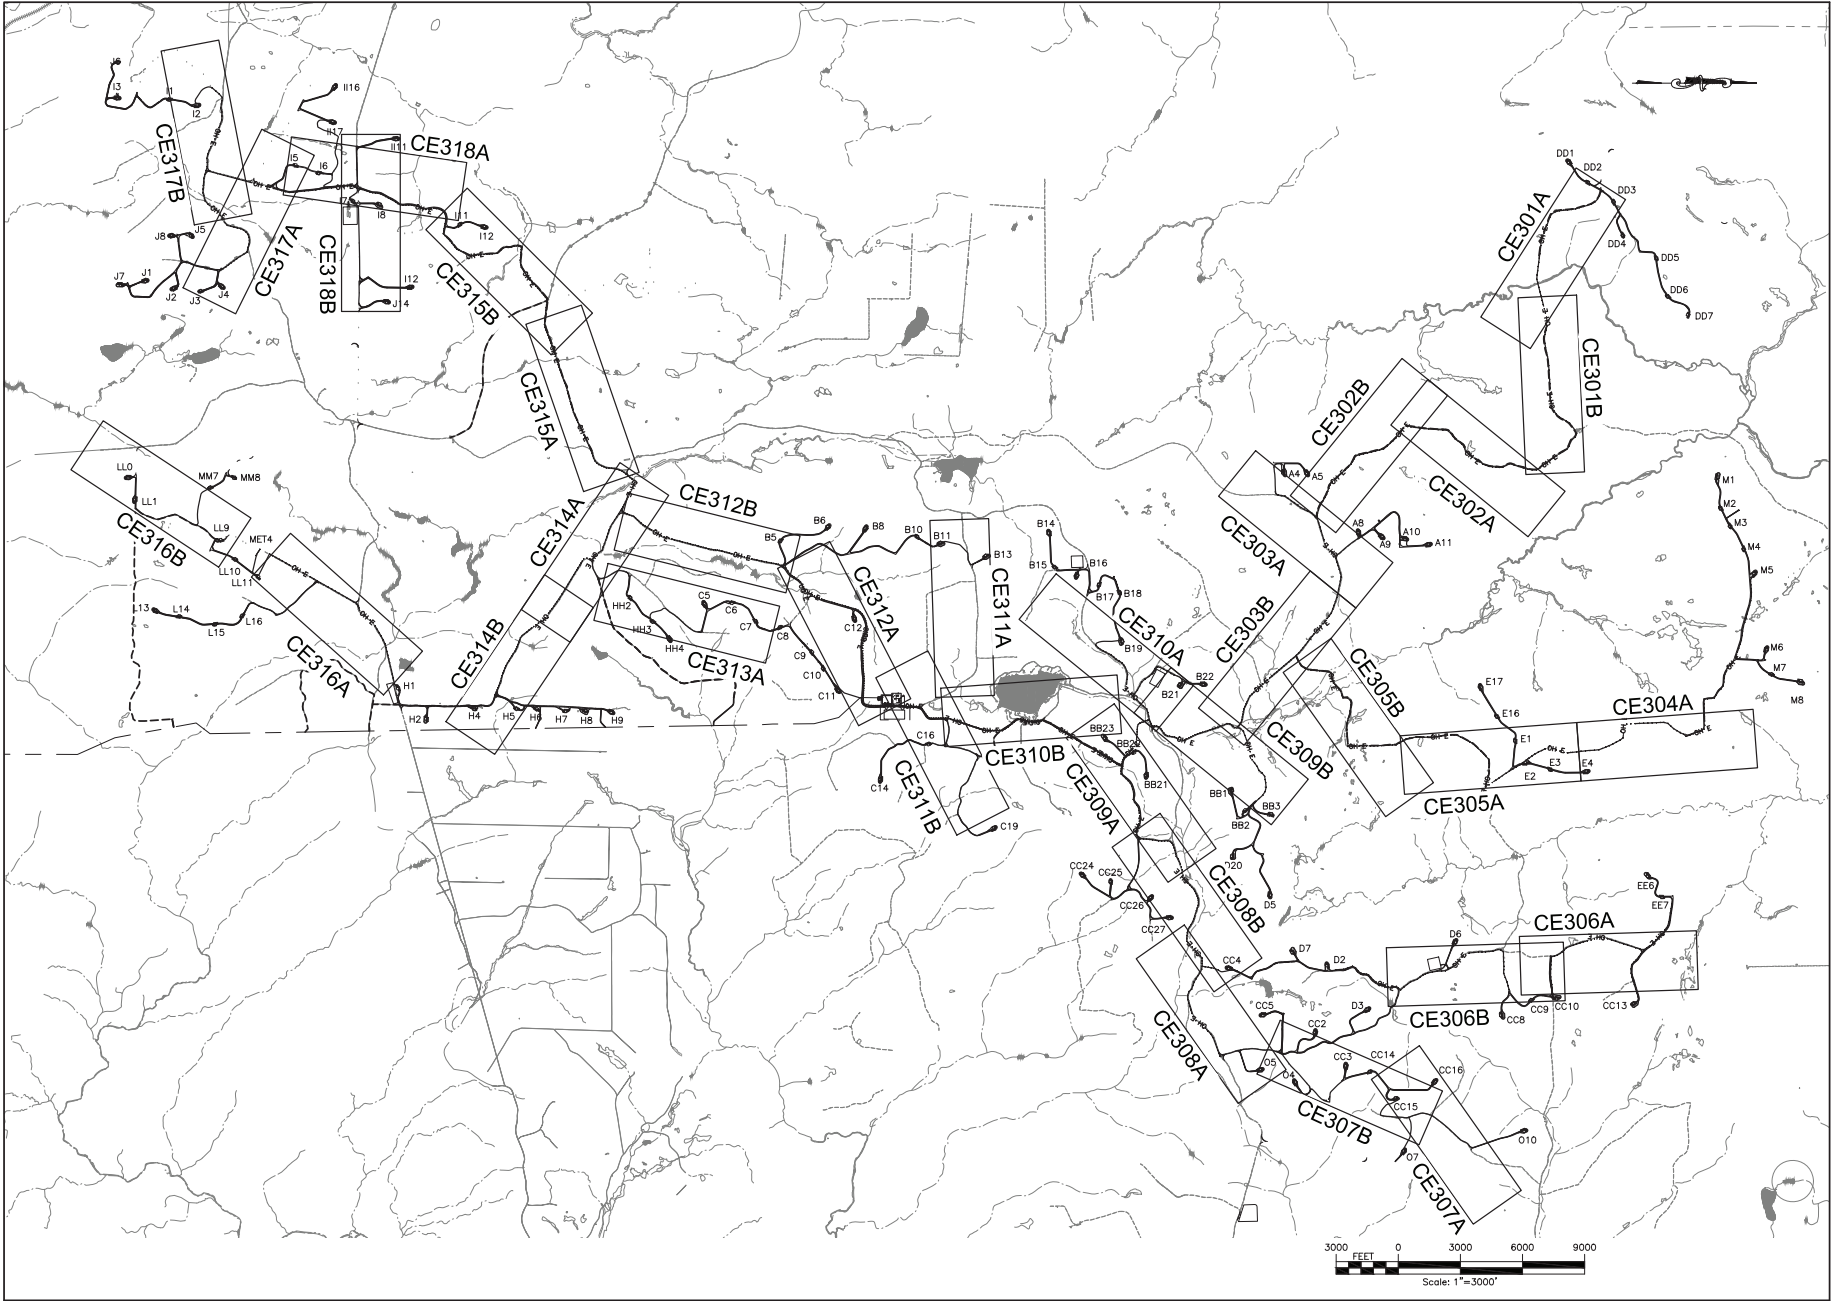


PROJECT: NUMBER NINE WIND FARM AROOSTOOK COUNTY, MAINE PRELIMINARY PLANS NOT FOR CONSTRUCTION		DRAWING NO. CE300 SHEET 279 OF 338	
TITLE OF DRAWING: COLLECTION LINE INDEX		PROJECT MANAGER: S. MELLOTT	
NUMBER NINE WIND FARM NUMBER NINE WIND FARM		ARCHITECT/ENGINEER: 140009	
COLLECTION LINE INDEX		CONTRACT NO. OR A.A. P.C. 140009	
PRELIMINARY PLANS NOT FOR CONSTRUCTION		DRAWN BY: BK	
NUMBER NINE WIND FARM		CHECKED BY: AS SHOWN	
COLLECTION LINE INDEX		DATE: JULY 2010	
PRELIMINARY PLANS NOT FOR CONSTRUCTION		REVISIONS: 1, 2, 3, 4, 5, 6, 7	
COLLECTION LINE INDEX		DESCRIPTION: (Empty)	
COLLECTION LINE INDEX		DATE: (Empty)	
COLLECTION LINE INDEX		BY: (Empty)	


FILE NAME: I:\Projects\140009\Num_Line_Mid_LSA_Veg_CAD\CAD\140009_CE301-CE303_Sheets.dwg
 USER: Steven Martel
 DATE: 3/26/08 PM

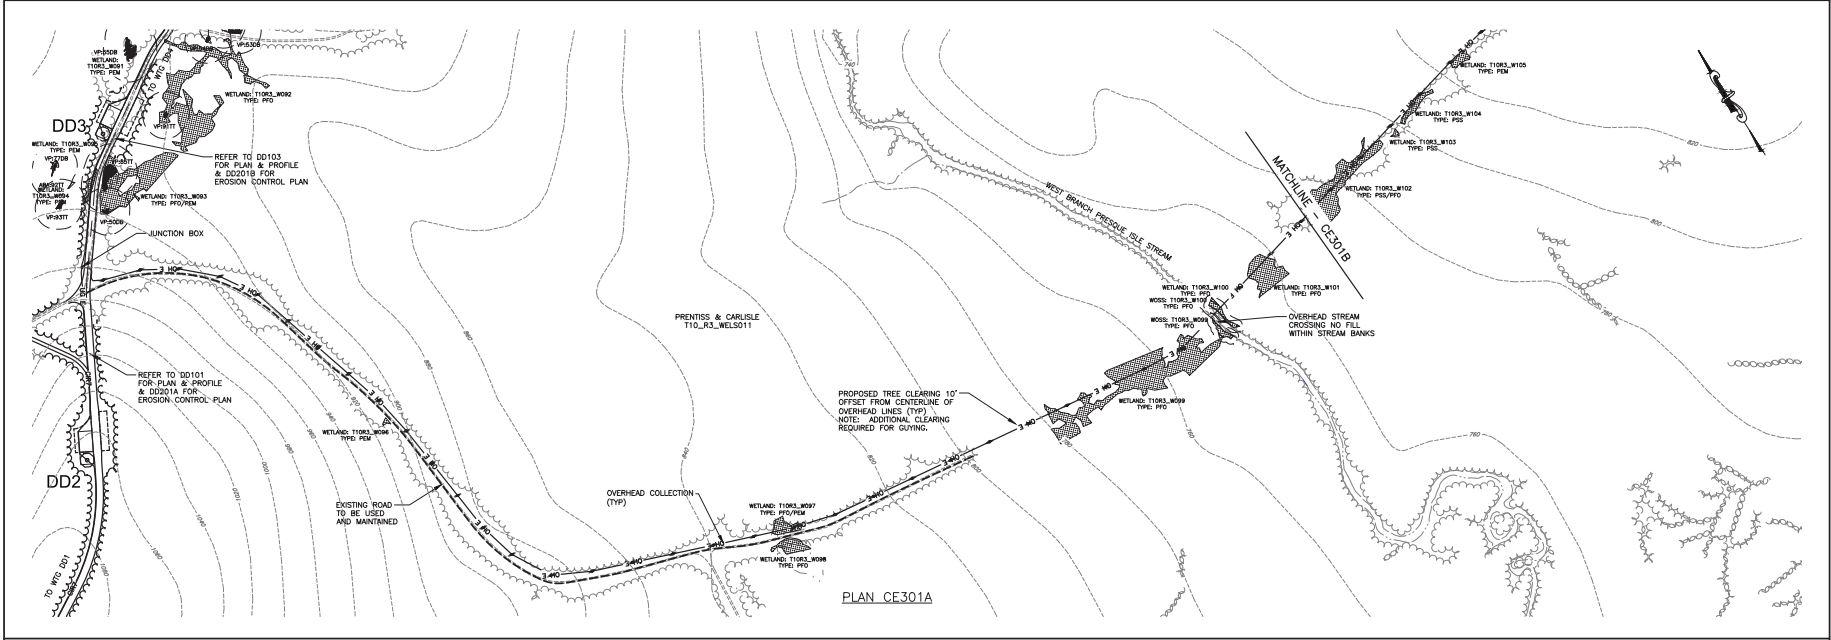

PLAN CE301A

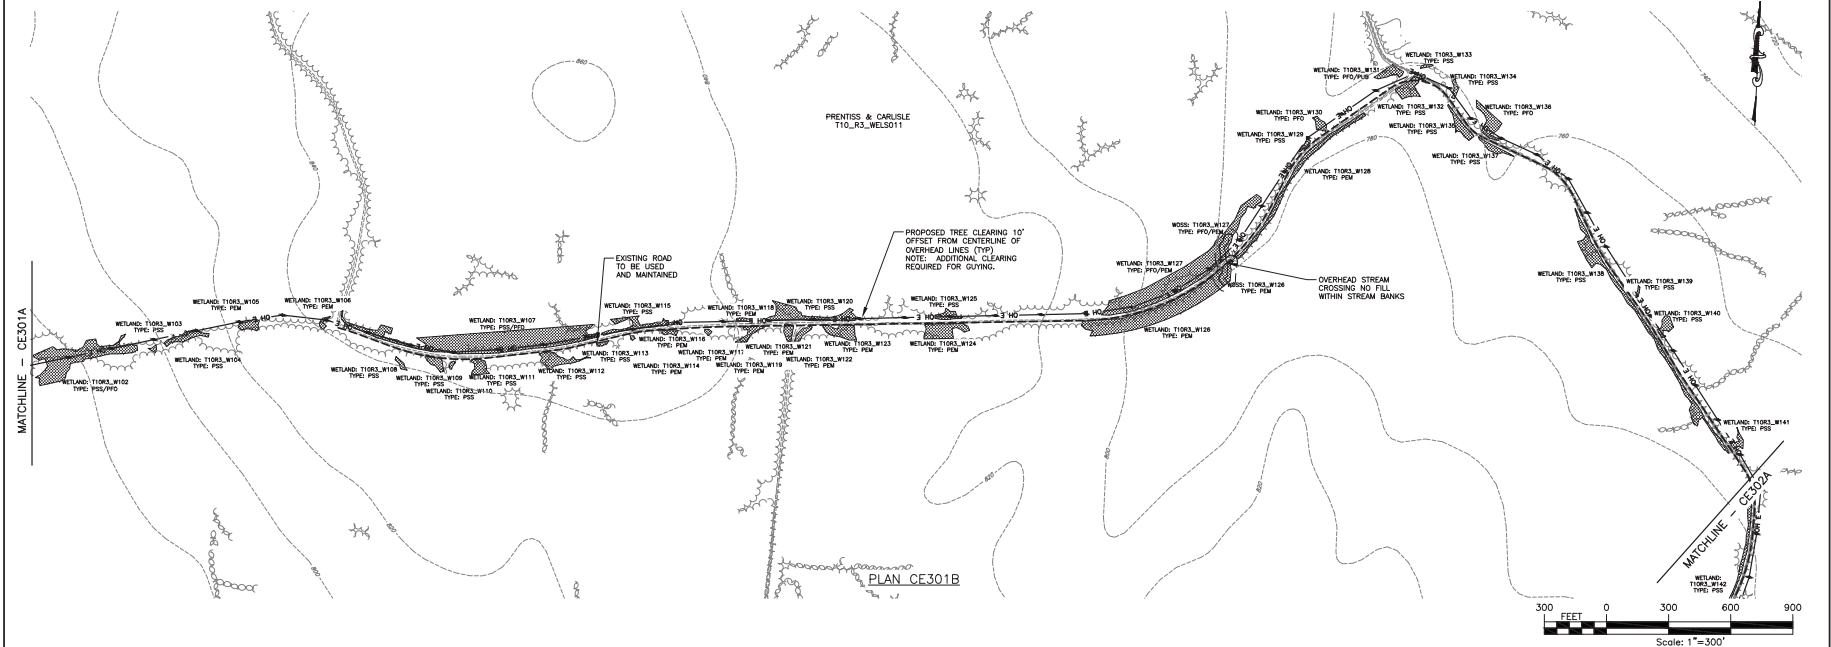


PLAN CE301B

 


PROJECT		NUMBER NINE WIND FARM ARDOOSTOOK COUNTY, MAINE PRELIMINARY PLANS NOT FOR CONSTRUCTION																																	
DRAWING NO.		CE301																																	
TITLE OF DRAWING		COLLECTION LINE PLAN																																	
DESIGNER		FISHKILL CONSULTANTS www.fishkillconsultants.com																																	
PROJECT MANAGER		S. MELLOTT																																	
DRAWN BY		DP/BA																																	
CHECKED BY		S. MELLOTT																																	
DATE		JULY 2015																																	
SCALE		AS SHOWN																																	
REVISIONS		<table border="1"> <tr> <th>REV</th> <th>DESCRIPTION</th> <th>DATE</th> <th>BY</th> </tr> <tr> <td>7</td> <td></td> <td></td> <td></td> </tr> <tr> <td>6</td> <td></td> <td></td> <td></td> </tr> <tr> <td>5</td> <td></td> <td></td> <td></td> </tr> <tr> <td>4</td> <td></td> <td></td> <td></td> </tr> <tr> <td>3</td> <td></td> <td></td> <td></td> </tr> <tr> <td>2</td> <td></td> <td></td> <td></td> </tr> <tr> <td>1</td> <td></td> <td></td> <td></td> </tr> </table>		REV	DESCRIPTION	DATE	BY	7				6				5				4				3				2				1			
REV	DESCRIPTION	DATE	BY																																
7																																			
6																																			
5																																			
4																																			
3																																			
2																																			
1																																			
FEDERAL PROJECT NO.		140009																																	
CONTRACT NO.		140009																																	
PROJECT NO.		140009																																	
PROJECT NAME		NUMBER NINE WIND FARM																																	
PROJECT LOCATION		ARDOOSTOOK COUNTY, MAINE																																	
PROJECT OWNER		NUMBER NINE WIND FARM																																	
PROJECT CONTACT		S. MELLOTT																																	
PROJECT PHONE		(207) 833-1111																																	
PROJECT FAX		(207) 833-1112																																	
PROJECT EMAIL		smellott@fishkillconsultants.com																																	
PROJECT WEBSITE		www.fishkillconsultants.com																																	

FILE NAME: I:\Projects\140009\Num_Nine_Mid_Form_LSA_Veg_GAO_CUA\140009_CE301-CE303_Sheets.dwg
 USER: SHERI MARSH
 DATE: 07/23/2015 3:43:58 PM

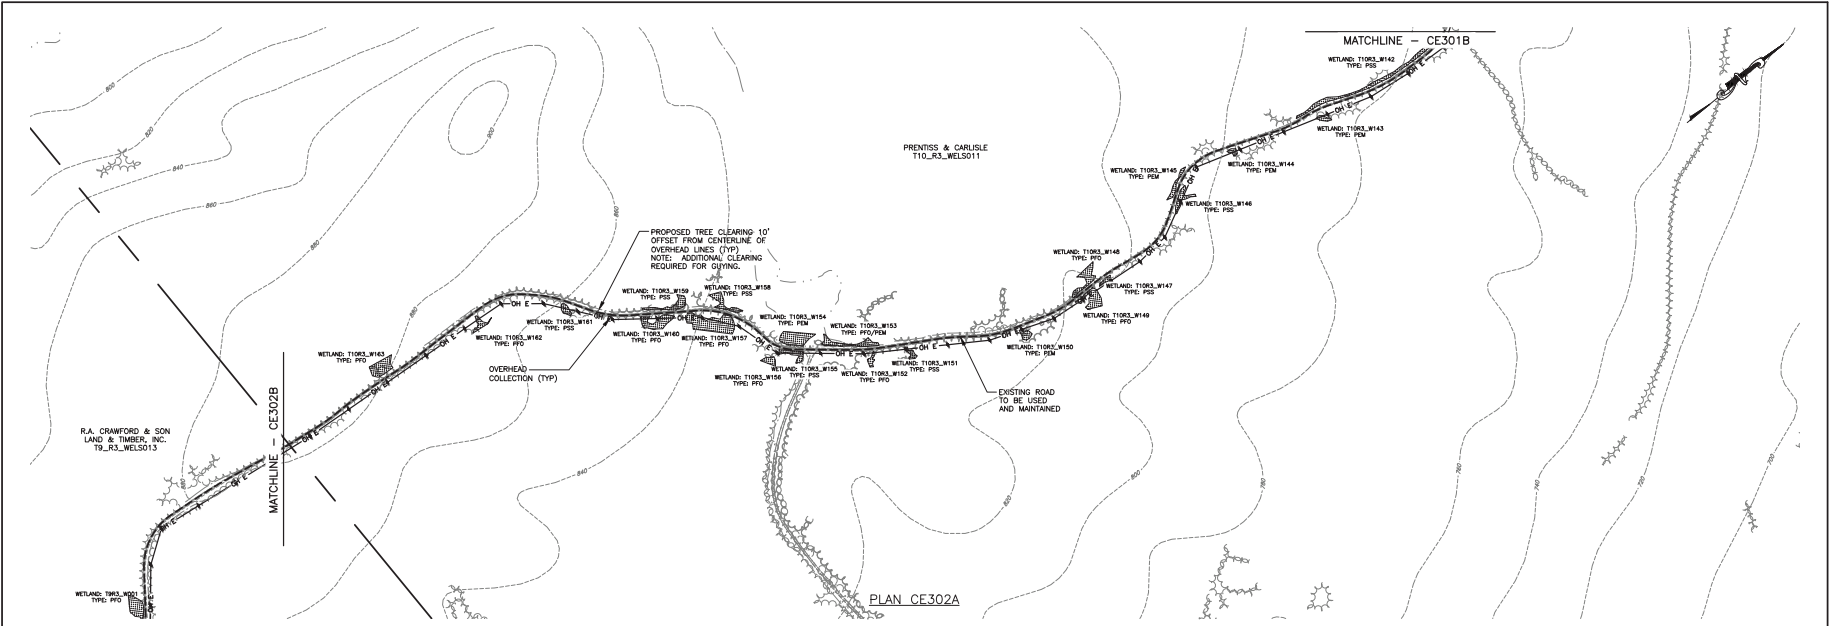

PLAN CE302A

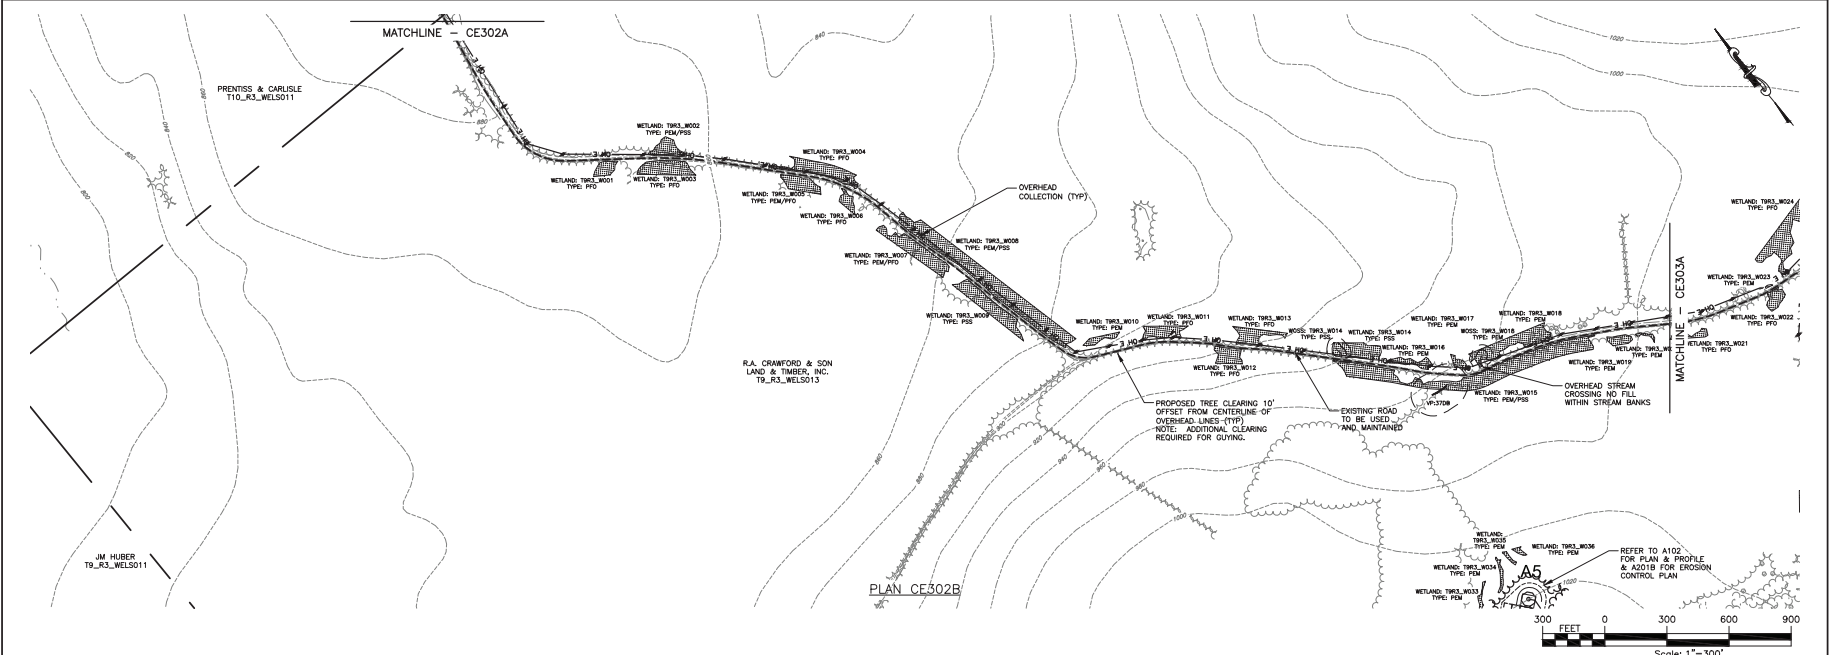


PLAN CE302B

PROJECT		DRAWING NO.	
NUMBER NINE WIND FARM ARROSTOCK COUNTY, MAINE PRELIMINARY PLANS NOT FOR CONSTRUCTION		CE302	
SUBJECT		TITLE (IF DIFFERENT)	
NUMBER NINE WIND FARM		COLLECTION LINE PLAN	
DRAWING NO.		SCALE	
CE302		AS SHOWN	
DATE		DATE	
JULY 2015		JULY 2015	
DESIGNED BY		CHECKED BY	
S. MELLOTT		S. MELLOTT	
DRAWN BY		SCALE	
D. P. BA		AS SHOWN	
PROJECT MANAGER		DATE	
S. MELLOTT		JULY 2015	
DESIGNED BY		DATE	
S. MELLOTT		JULY 2015	
DRAWN BY		DATE	
D. P. BA		JULY 2015	
CHECKED BY		DATE	
S. MELLOTT		JULY 2015	
DATE		DATE	
JULY 2015		JULY 2015	




REFER TO A102 FOR PLAN & PROFILE & A211B FOR EROSION CONTROL PLAN


FILE NAME: I:\Projects\140009\Num_Nine_Wind_Farm_LSA\Drawings\140009_CE301-CE303_Sheets.dwg
 USER: Steven_Marini
 DATE: 7/26/16 10:34:25 AM

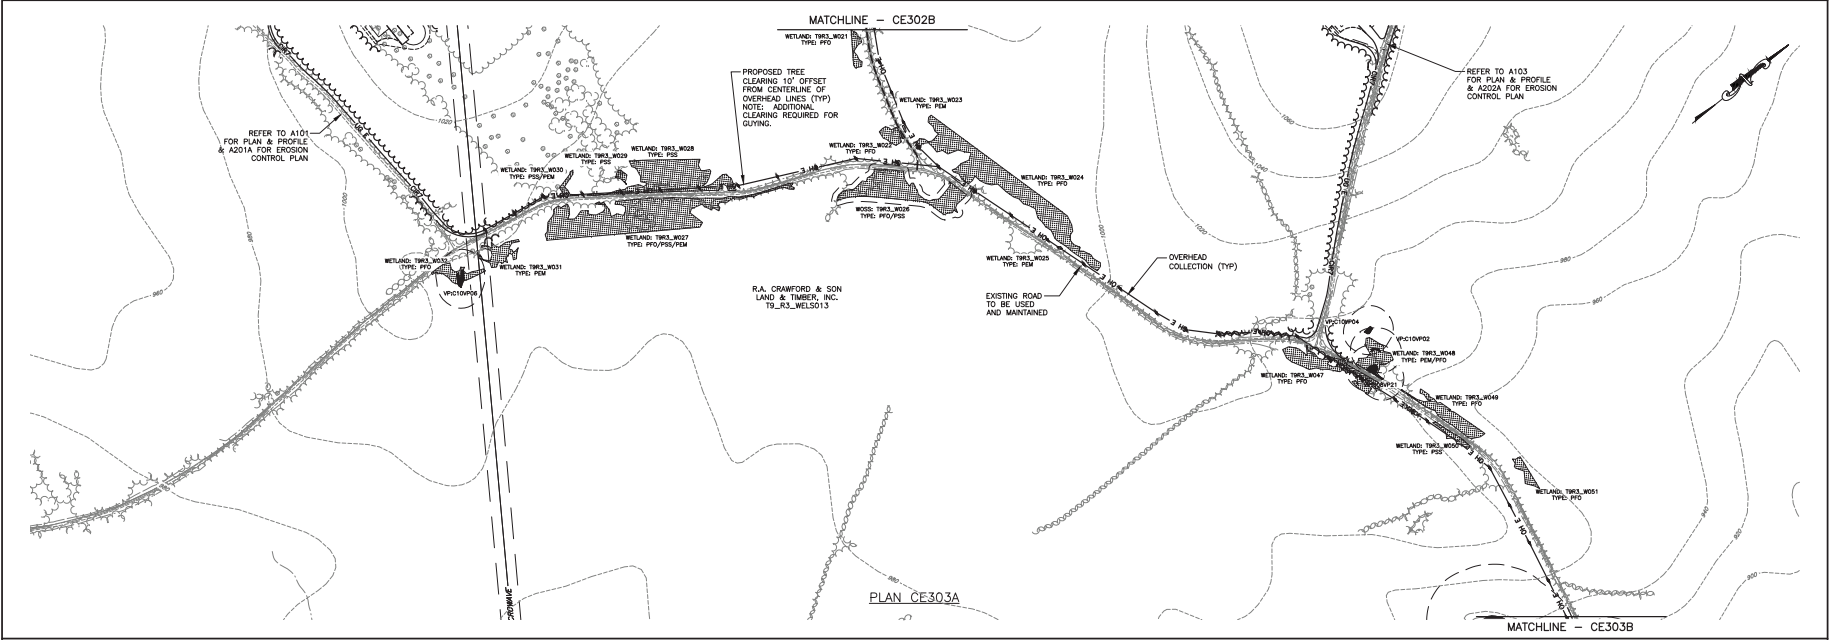

PLAN CE303A

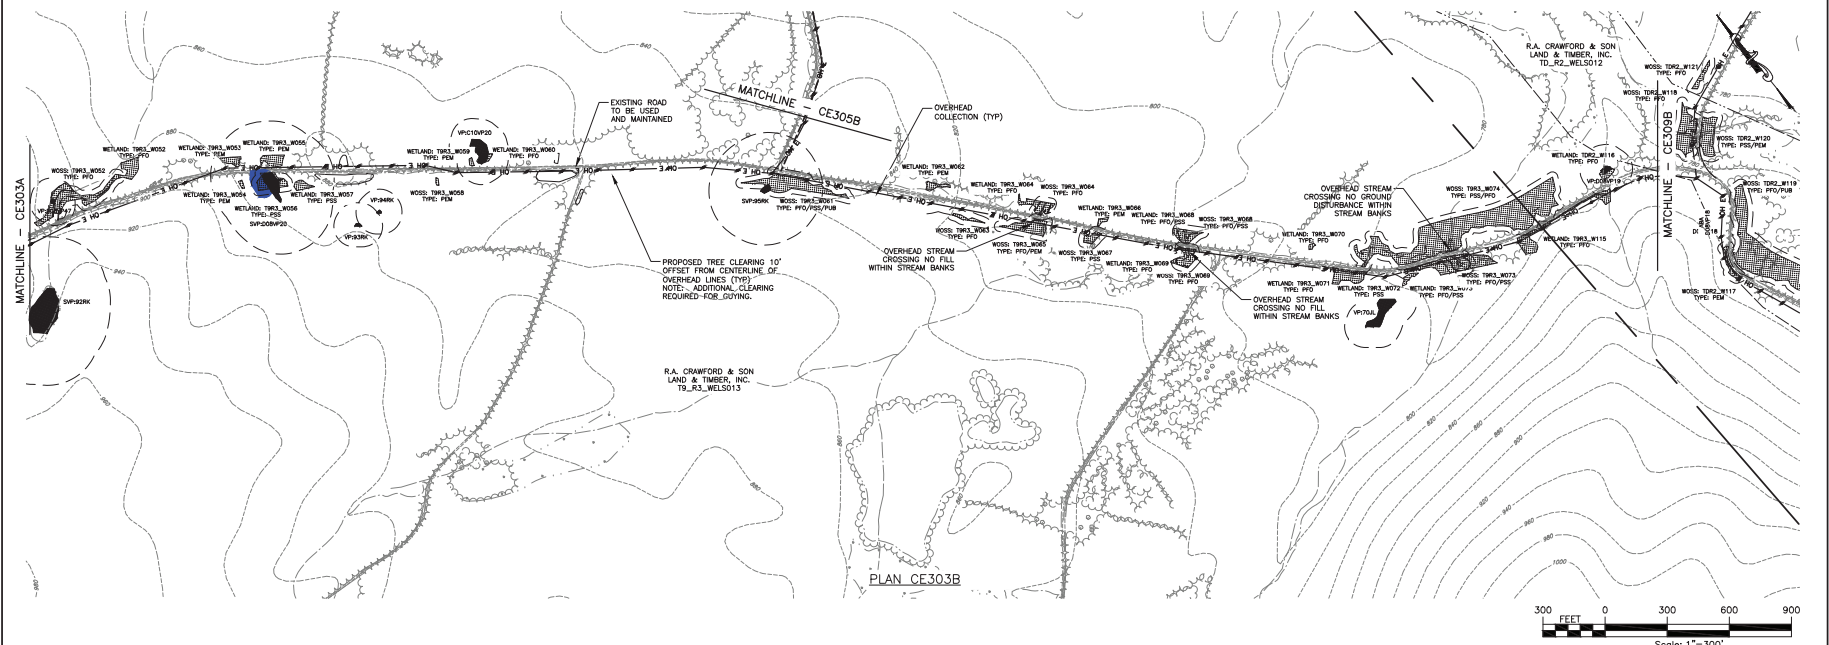

PLAN CE303B

 



REV	DESCRIPTION	DATE	BY
1			
2			
3			
4			
5			
6			
7			

PROJECT NO. 140009
 PROJECT MANAGER S. MELLOTT
 EXAMINER DPBA
 SCALE AS SHOWN
 SHEET DATE JULY 2016



PROJECT: NUMBER NINE WIND FARM
 AROOSTOOK COUNTY, MAINE
 PRELIMINARY PLANS NOT FOR CONSTRUCTION
 TITLE OF DRAWING: COLLECTION LINE PLAN

 DRAWING NO. CE303
 SHEET 292 OF 338

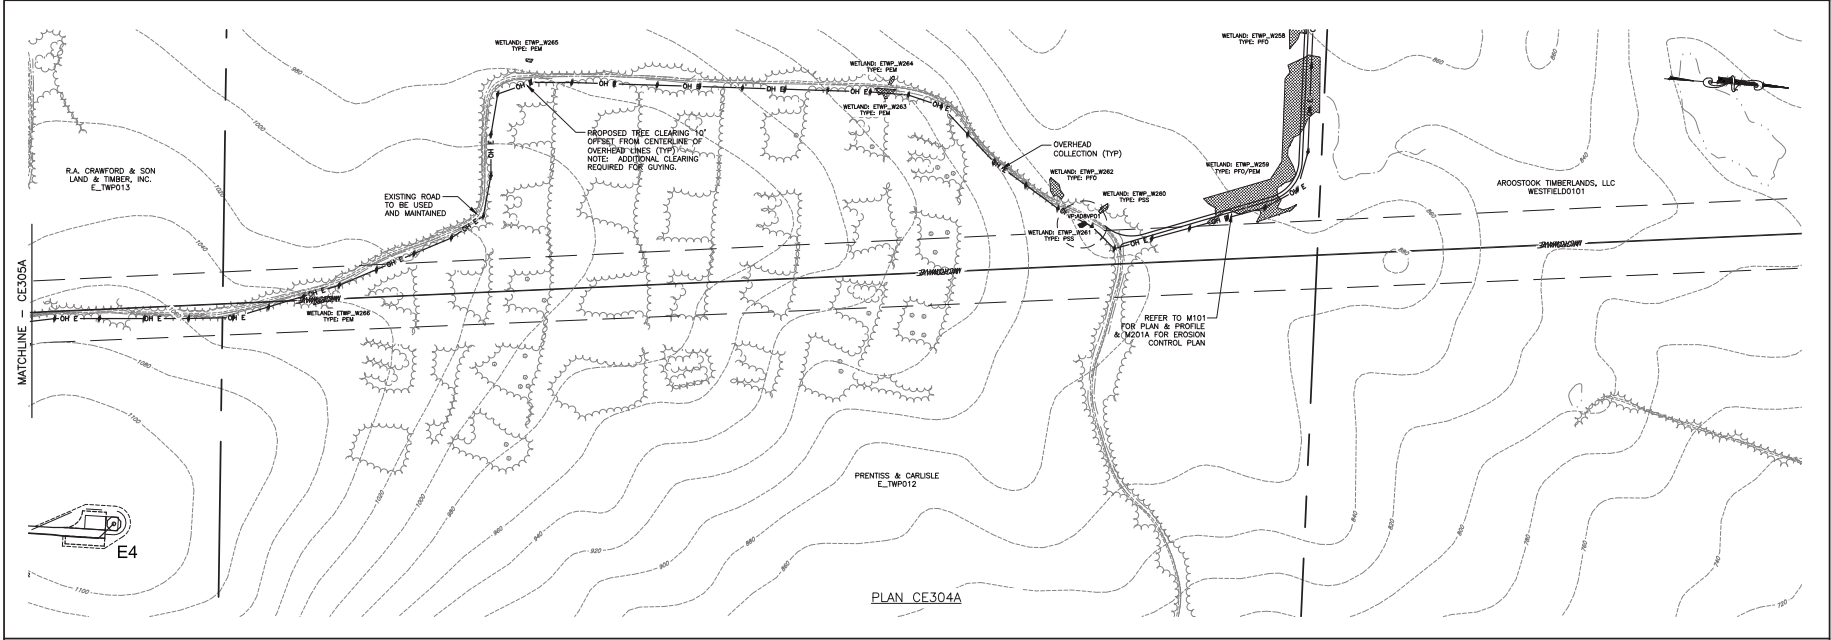

REV	DESCRIPTION	DATE	BY
1			
2			
3			
4			
5			
6			
7			

CONTRACT NO. 140009
 PROJECT MANAGER
 S. MELLOTT
 EXAMINER
 BK
 SCALE
 AS SHOWN
 SHEET DATE
 JULY 2016

PROJECT
 NUMBER NINE WIND FARM
 AROOSTOOK COUNTY, MAINE
 PRELIMINARY PLANS NOT FOR CONSTRUCTION
 NUMBER NINE WIND FARM
 TITLE OF DRAWING
 COLLECTION LINE PLAN



DRAWING NO.
CE304
 SHEET 283 OF 338



PROJECT
 NUMBER NINE WIND FARM
 AROOSTOOK COUNTY, MAINE
 PRELIMINARY PLANS NOT FOR CONSTRUCTION
 NUMBER NINE WIND FARM
 TITLE OF DRAWING
 COLLECTION LINE PLAN



DRAWING NO.
CE304
 SHEET 283 OF 338

FILE NAME: I:\Projects\140009\Num_Nine_Wind_Farm_LSA_Vray\04\CE305A-CE304-CE306 Sheets.dwg
 DATE PLOTTED: 7/26/19 PM
 USER: Steven_Marlot

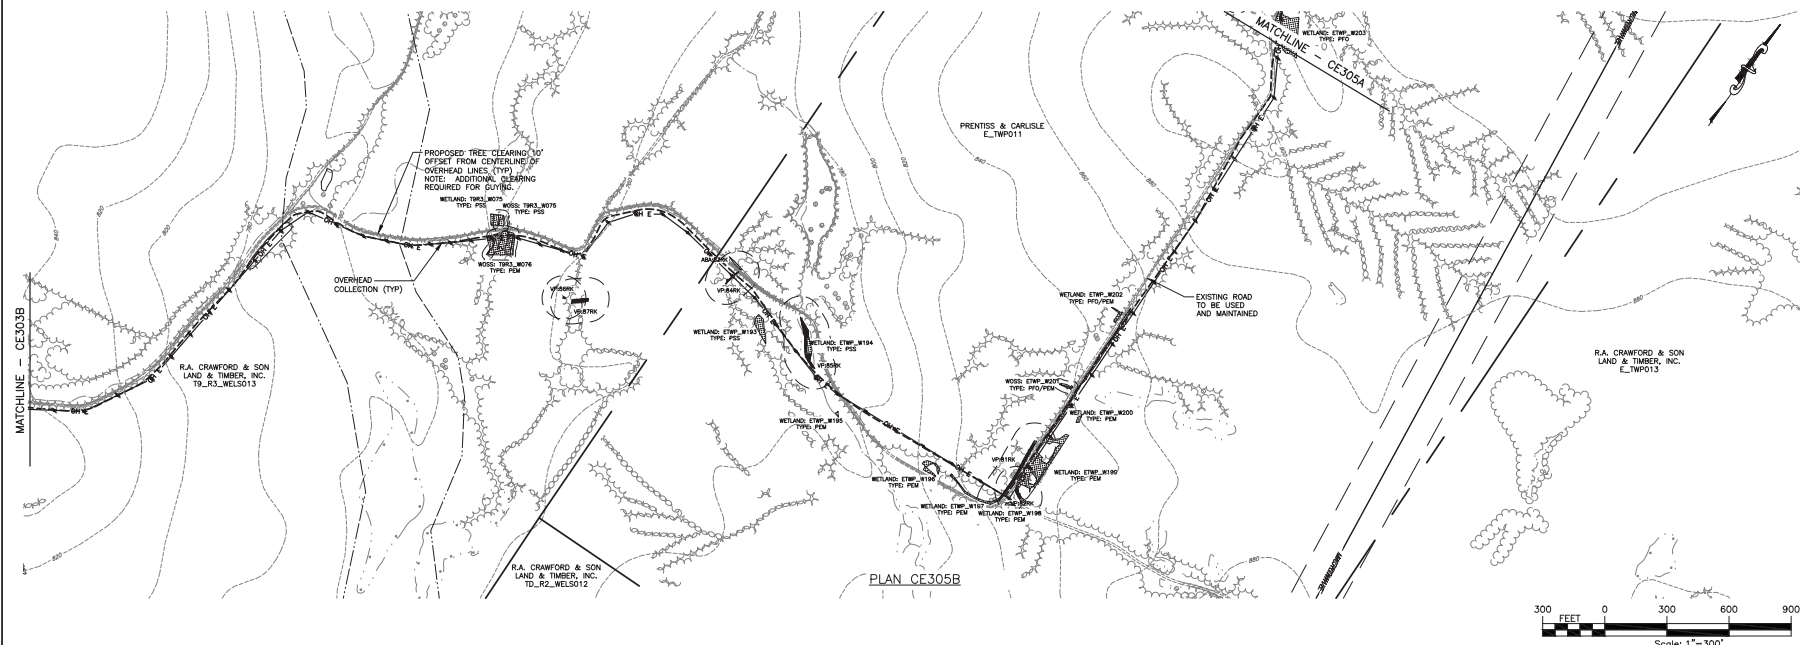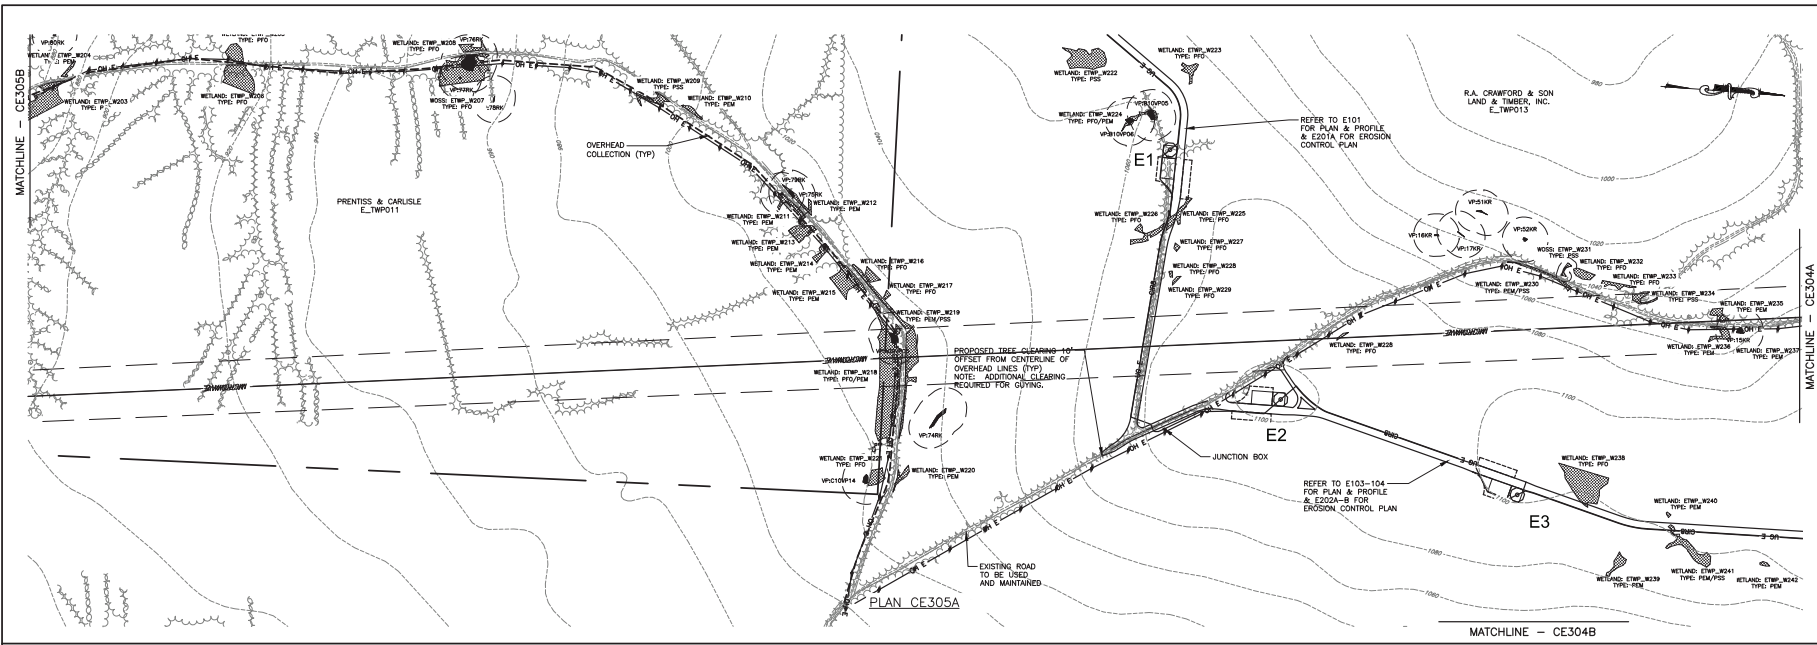

PROJECT:	NUMBER NINE WIND FARM AROSTOOK COUNTY, MAINE PRELIMINARY PLANS NOT FOR CONSTRUCTION
DRAWING NO.:	CE305
TITLE OF DRAWING:	COLLECTION LINE PLAN
DESIGNER:	FILETERRAIN ASSOCIATES www.fileterrain.com 1000 Main Street, Suite 100 Portland, ME 04101 Tel: 603.761.1000
PROJECT MANAGER:	S. MELLOTT
EXAMINER:	BK
SCALE:	AS SHOWN
DATE:	JULY 2019
REV:	1
DESCRIPTION:	
DATE:	
BY:	

FILE NAME: I:\Projects\140009\Num_Nine_Wind_Farm_LSA_Veg_CAD\CAD\140009_CED04-CE306_Sheets.dwg
 DATE: 3/25/15 PM
 USER: Steven Marlot

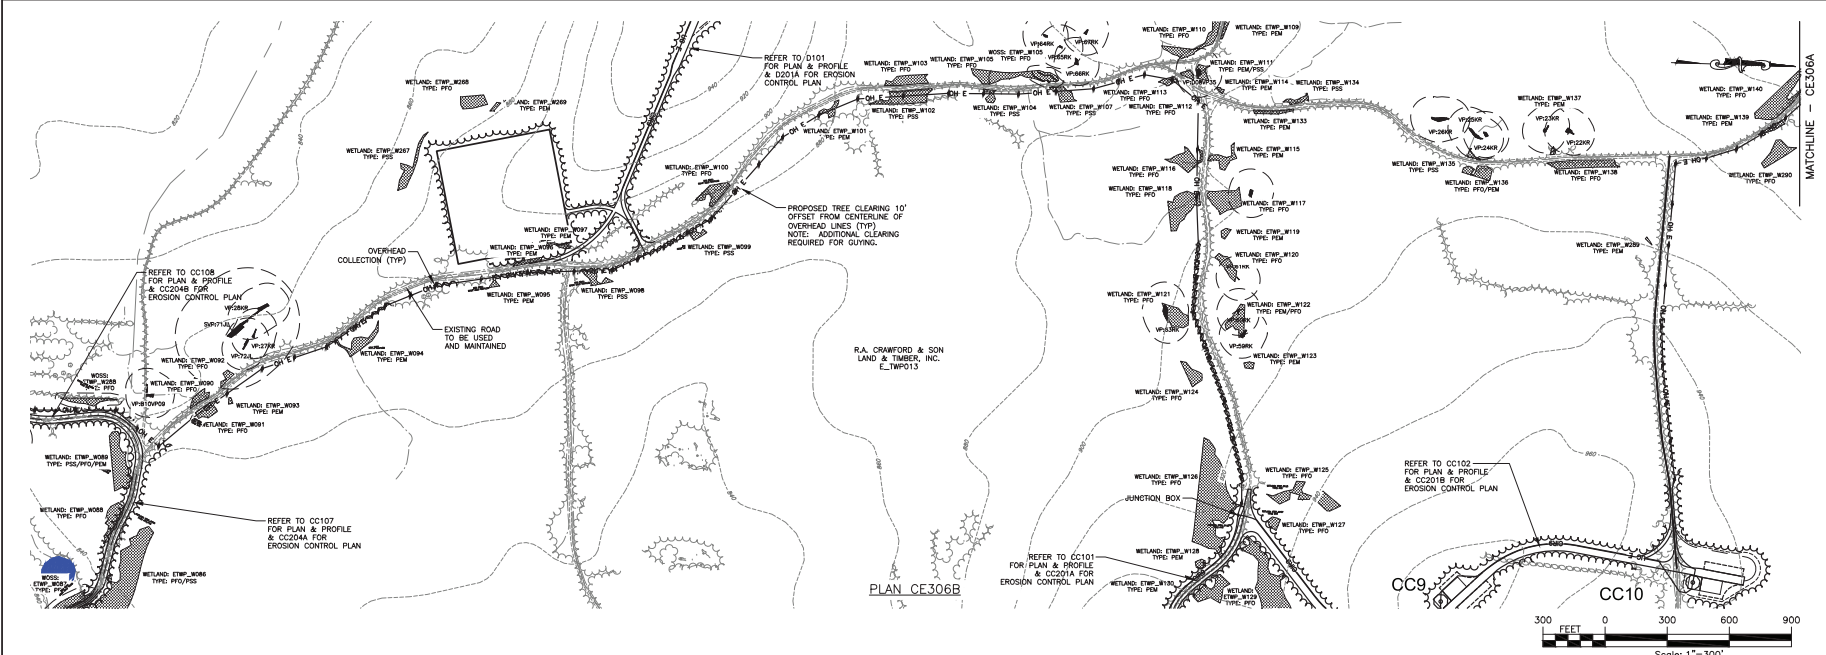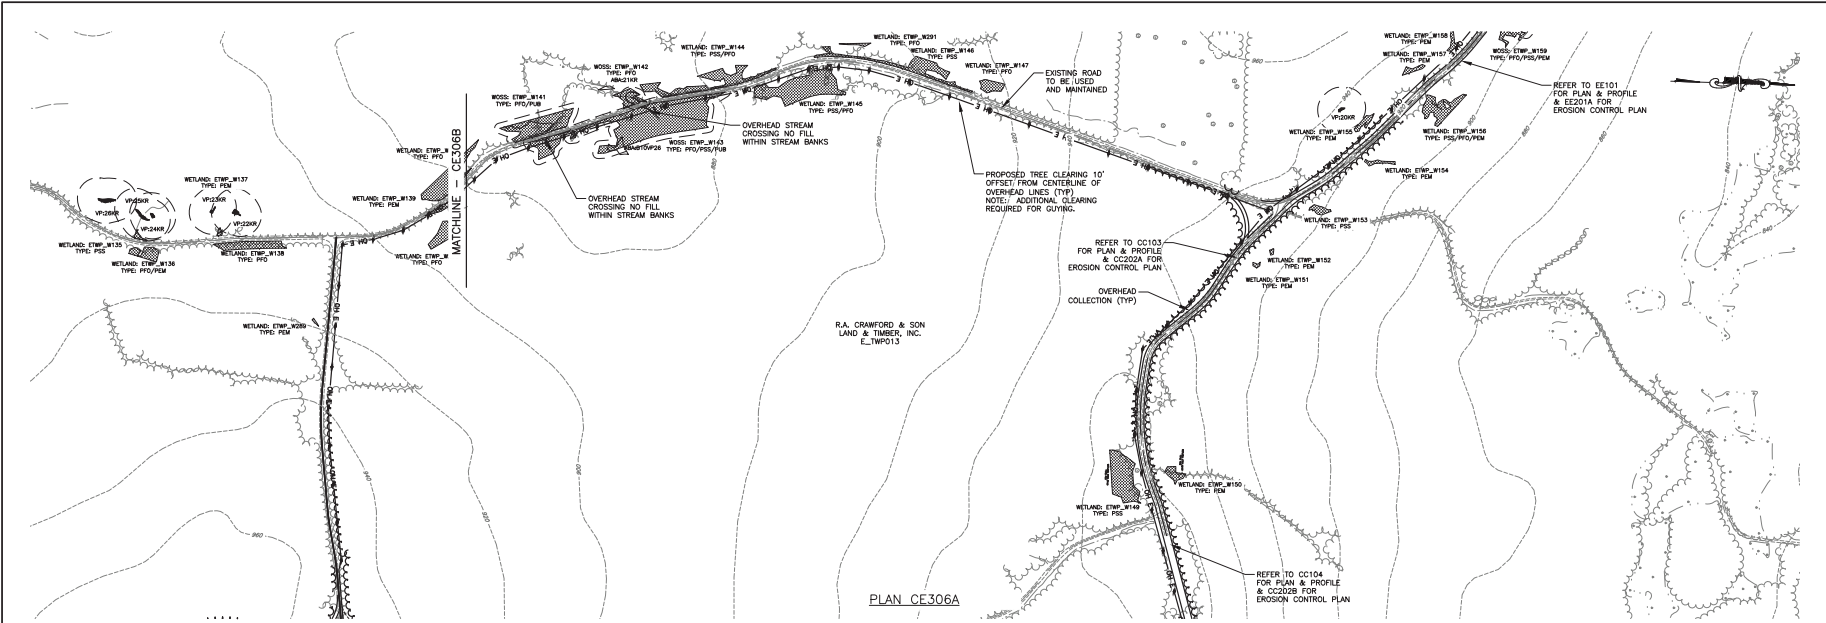


REV	DESCRIPTION	DATE	BY
1			
2			
3			
4			
5			
6			
7			

PROJECT NO.	140009
PROJECT MANAGER	S. MELLOTT
DESIGNED BY	BK
CHECKED BY	AS SHOWN
DATE	JULY 2015


PROJECT	NUMBER NINE WIND FARM ARCOOSTOOK COUNTY, MAINE PRELIMINARY PLANS NOT FOR CONSTRUCTION
DRAWING NO.	CE306
TITLE OF DRAWING	COLLECTION LINE PLAN
DATE	
BY	

CONTRACT NO. 2014-11	ISSUE DATE
CONTRACTOR: S. L. L. S., P.C.	
DESIGNER: S. L. L. S., P.C.	
DATE: 7/15/15	
SCALE: AS SHOWN	







FILE NAME: I:\Projects\140009\Num_Nine_Wind_Farm_LSA_V01.dwg (A/C) 140009 CE307-CE309 Sheets.dwg
 DATE: 07/26/16 10:36:52 AM
 USER: Steven M. Bost

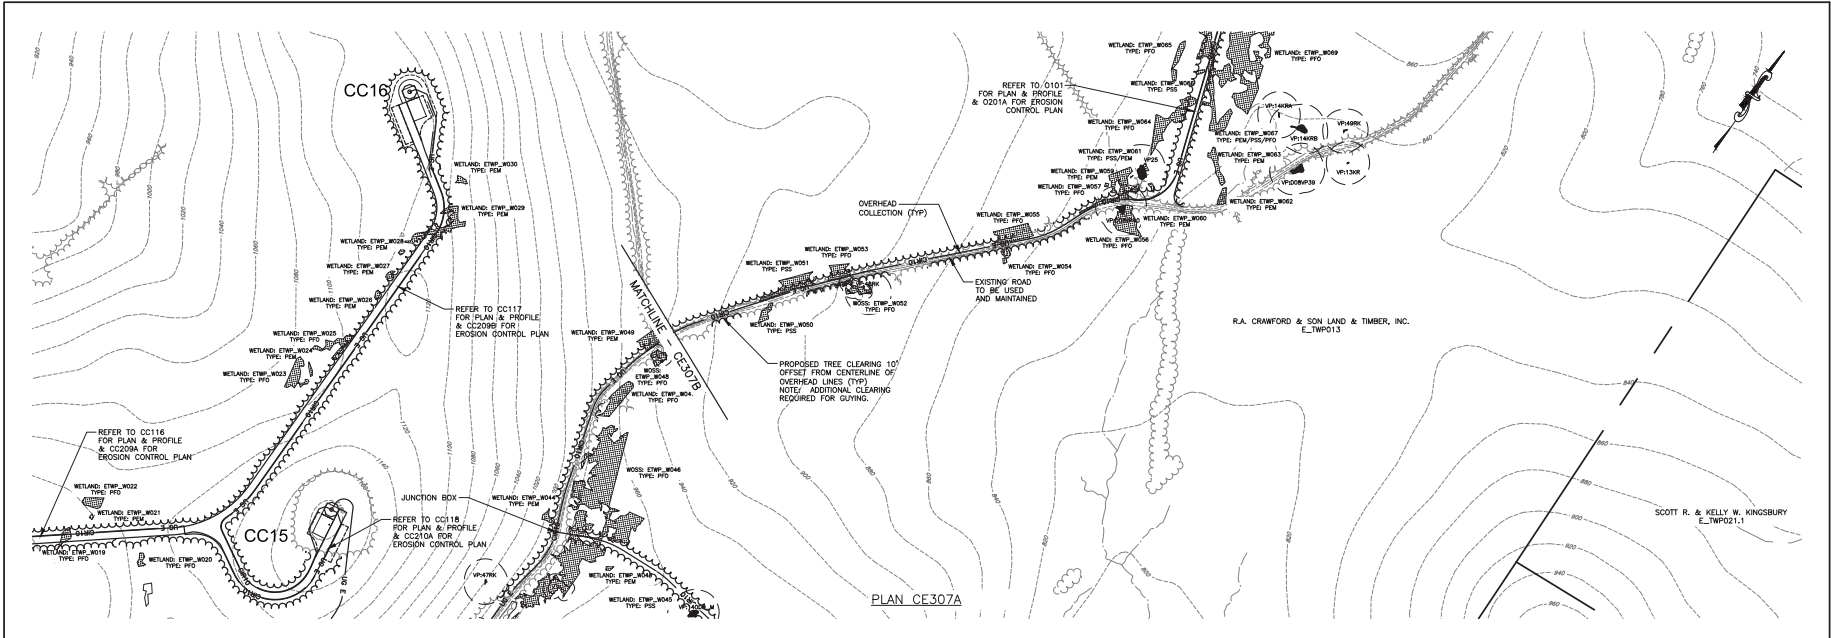

PLAN CE307A

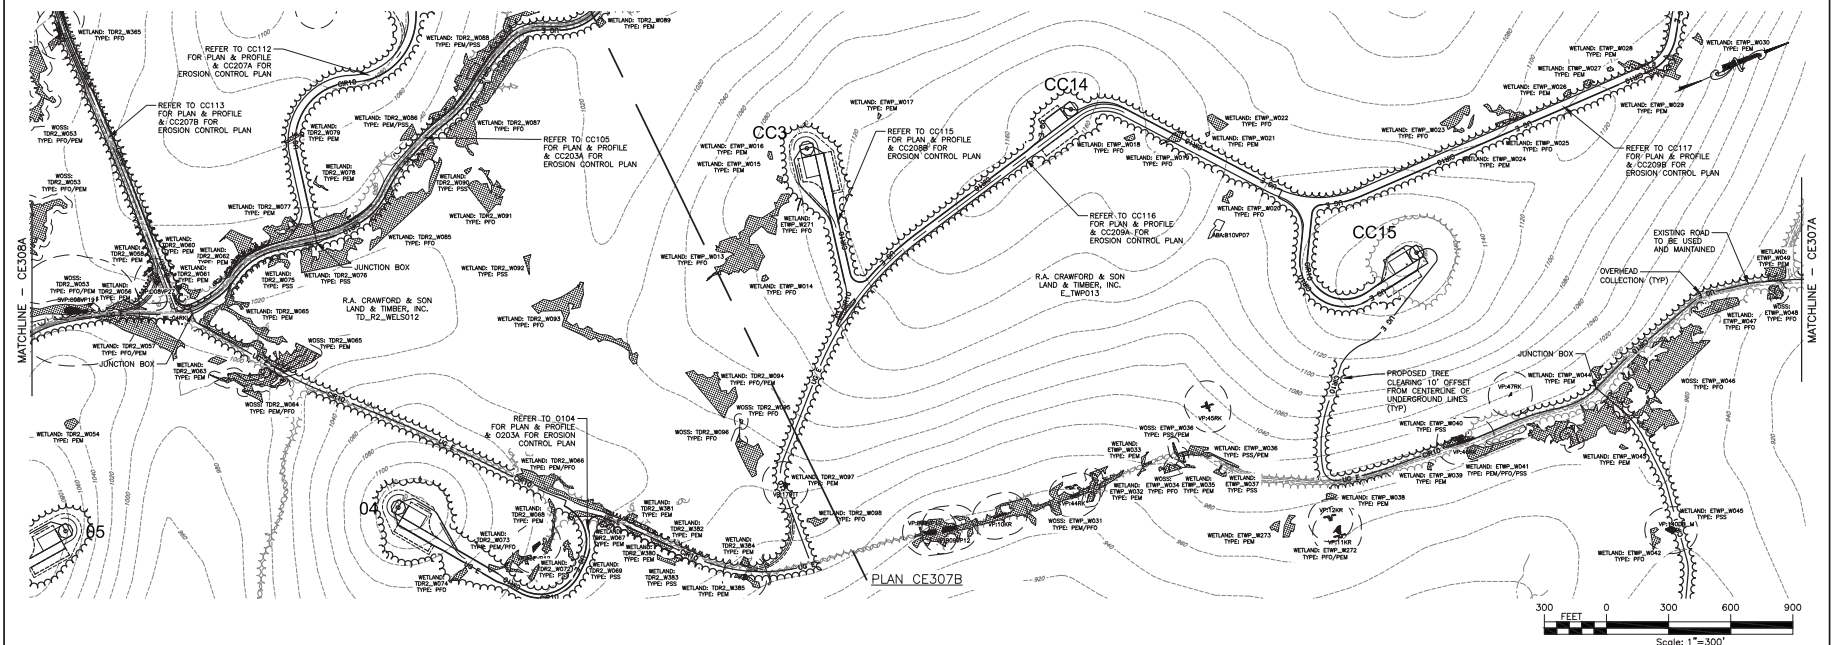

PLAN CE307B


 


DRAWING NO. CE307		SHEET 296 OF 338	
PROJECT: NUMBER NINE WIND FARM AROOSTOOK COUNTY, MAINE PRELIMINARY PLANS NOT FOR CONSTRUCTION			
TITLE OF DRAWING: COLLECTION LINE PLAN		NUMBER NINE WIND FARM	
DESIGNER: S. MELLOTT		CHECKED BY: BK	
DATE: JULY 2016		AS SHOWN	
REVISIONS:		DESCRIPTION:	
7			
6			
5			
4			
3			
2			
1			



WIND FARM ASSOCIATES, INC.
 1000 WIND FARM ROAD
 AROOSTOOK COUNTY, MAINE 04816
 TEL: (207) 833-1111
 WWW.WINDFARMASSOCIATES.COM




FILE NAME: I:\Projects\140009\Num_Nine_Wind_Farm_LBA\Drawings\CE307-CE309 Sheets.dwg
 DATE: 07/26/2016 10:38:50 PM
 USER: Steven Martini

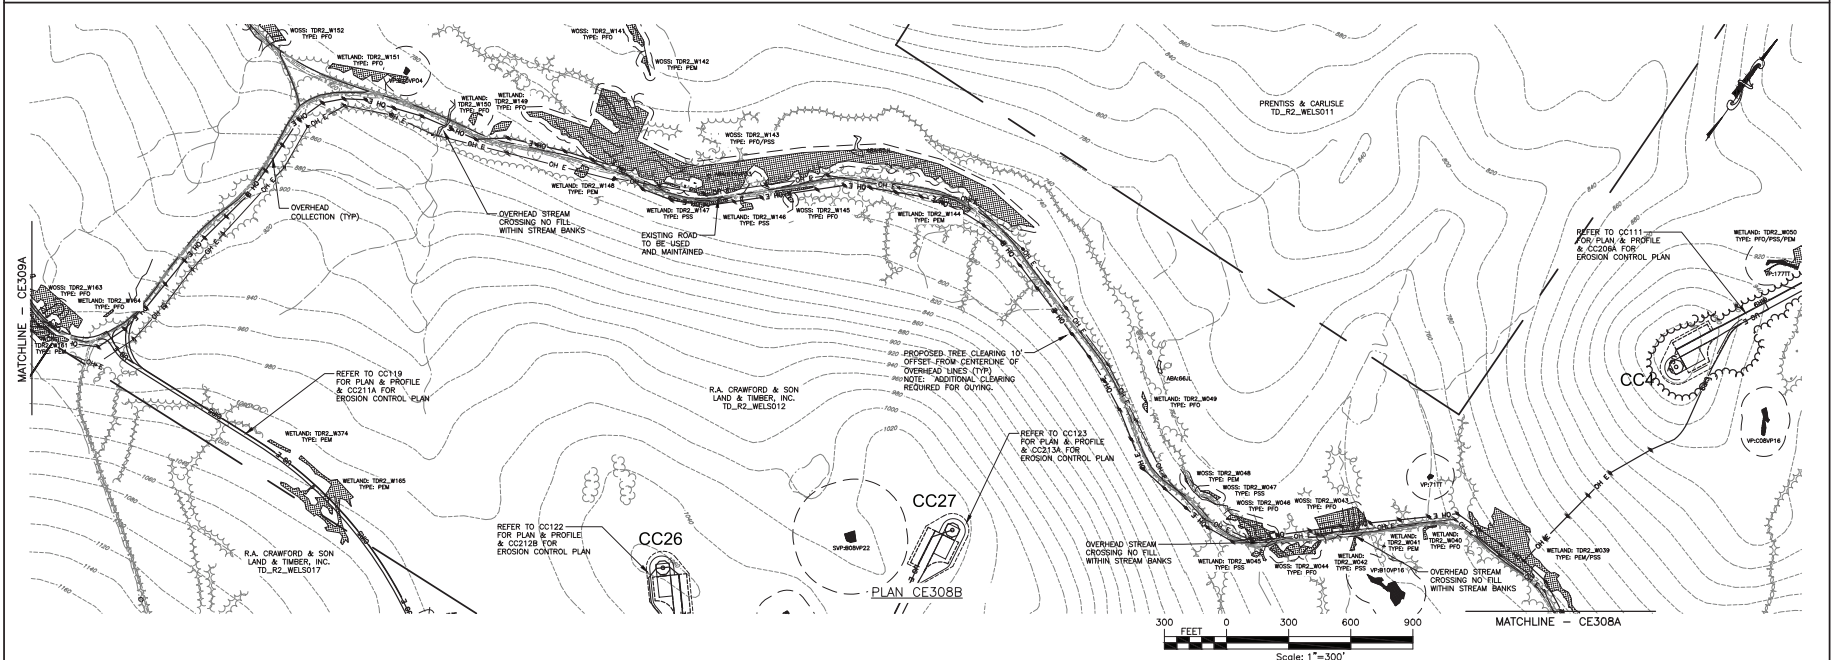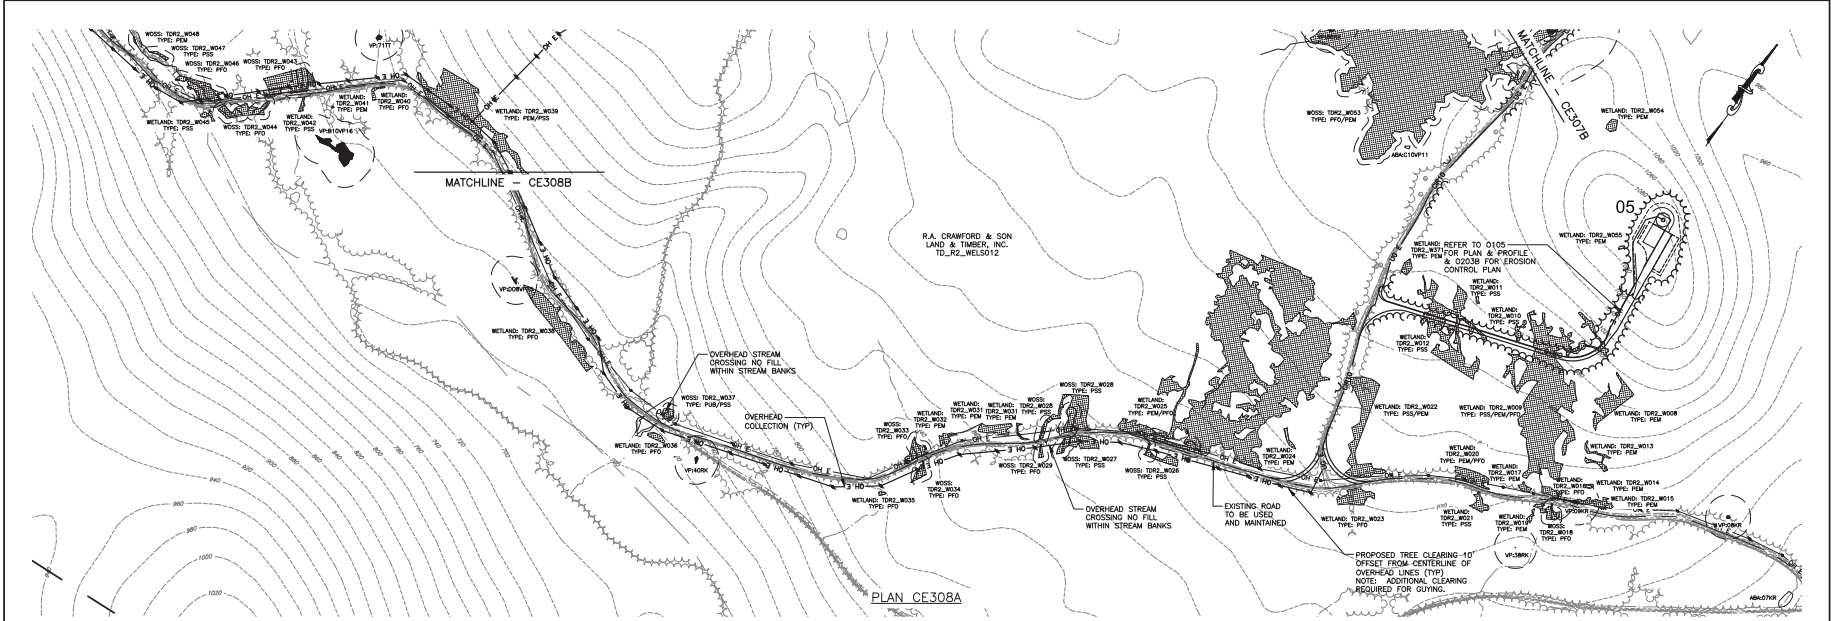

DRAWING NO. CE308		SHEET 287 OF 338	
PROJECT: NUMBER NINE WIND FARM AROOSTOOK COUNTY, MAINE PRELIMINARY PLANS NOT FOR CONSTRUCTION			
TITLE OF DRAWING: COLLECTION LINE PLAN		NUMBER NINE WIND FARM	
DESIGNER: S. MELLOTT		DATE: JULY 2015	
CHECKED BY: BK		SCALE: AS SHOWN	
APPROVED BY: S. MELLOTT		DATE: JULY 2015	
PROJECT MANAGER: S. MELLOTT		REV	
DATE:		7	
DESCRIPTION:		6	
DATE:		5	
DESCRIPTION:		4	
DATE:		3	
DESCRIPTION:		2	
DATE:		1	
DESCRIPTION:			





 FILE NAME: I:\Projects\140009\Num_Nine_Wind_Mid_LSA_Veg_CAD\CAD\140009_CE307-CE309_Sheets.dwg
 DATE: 7/2/2016 PM
 USER: Steven Maroti

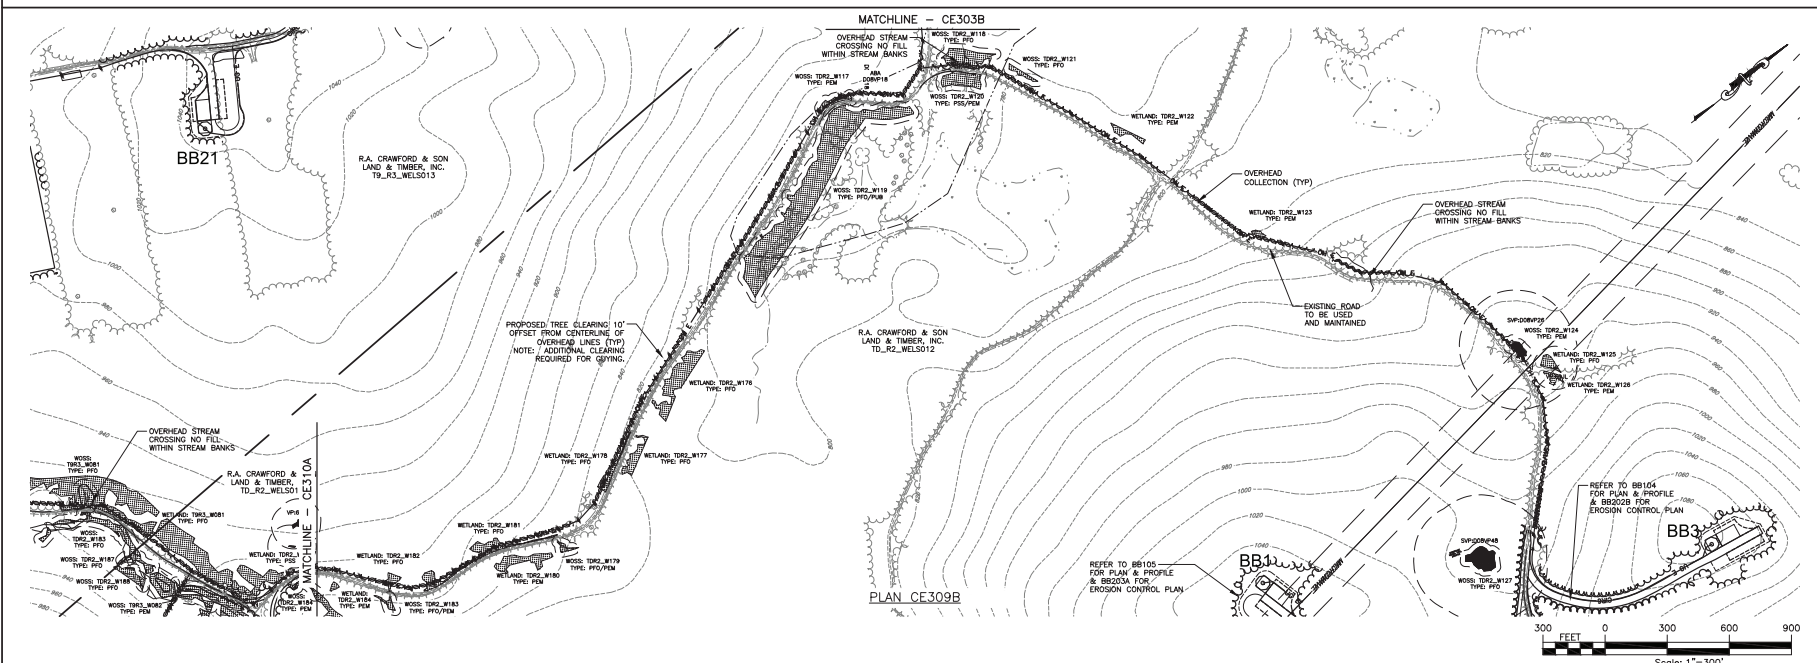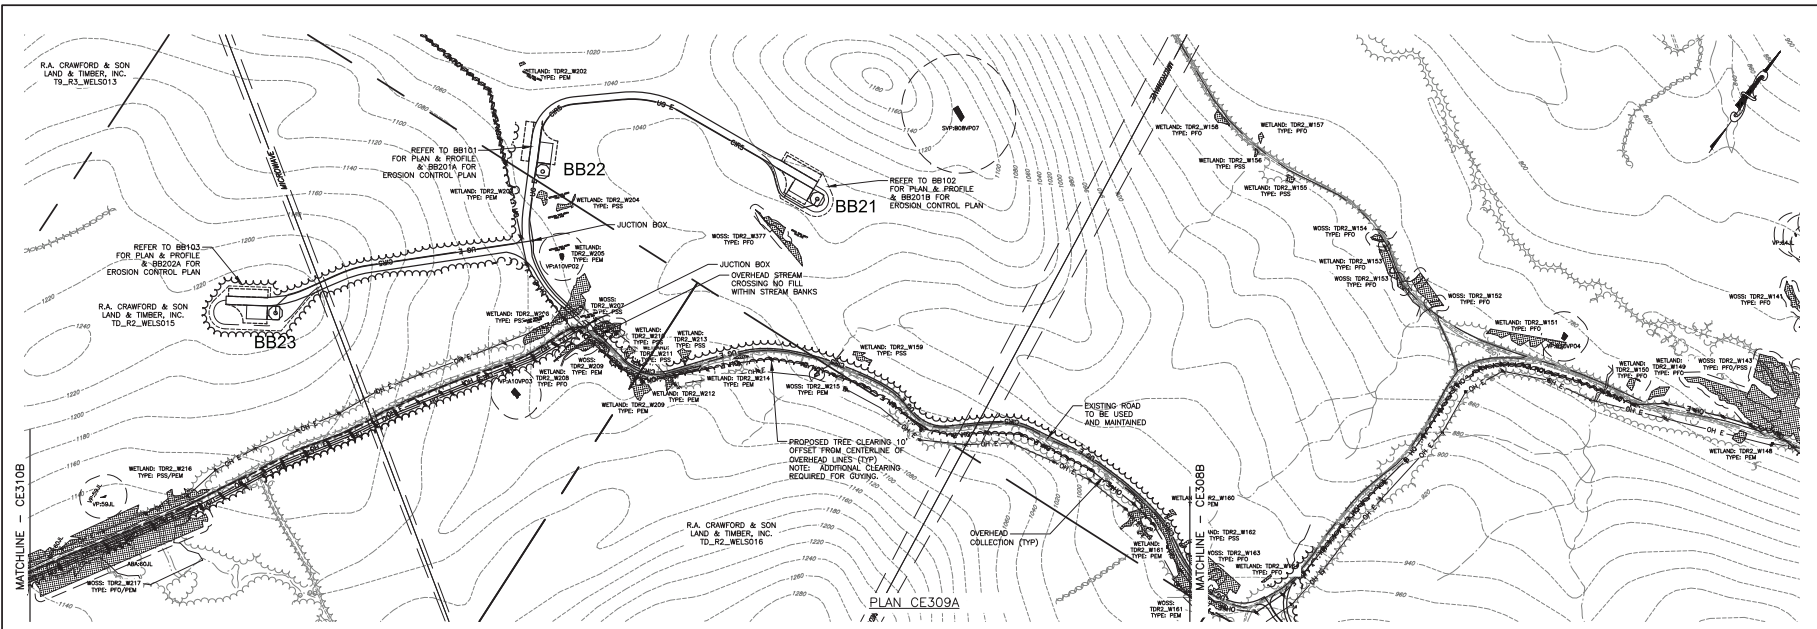


DRAWING NO. CE309	SHEET 288 OF 338	TITLE OF DRAWING COLLECTION LINE PLAN	PROJECT NUMBER NINE WIND FARM ARCOOCH COUNTY, MAINE PRELIMINARY PLANS NOT FOR CONSTRUCTION	NUMBER NINE WIND FARM	 FISH HAWK ASSOCIATES www.fishhawk.com	PREPARED BY S. MELLOTT	CHECKED BY BK	DATE JULY 2016
						APPROVED BY AS SHOWN	REVISIONS	DESCRIPTION


FILE NAME: I:\Projects\140009\Num_Nine_Wind_Main_ESA\Drawings\140009_CE310-CE313_Sheets.dwg
 USER: Steve_Marlot
 DATE: 4/28/19 PM

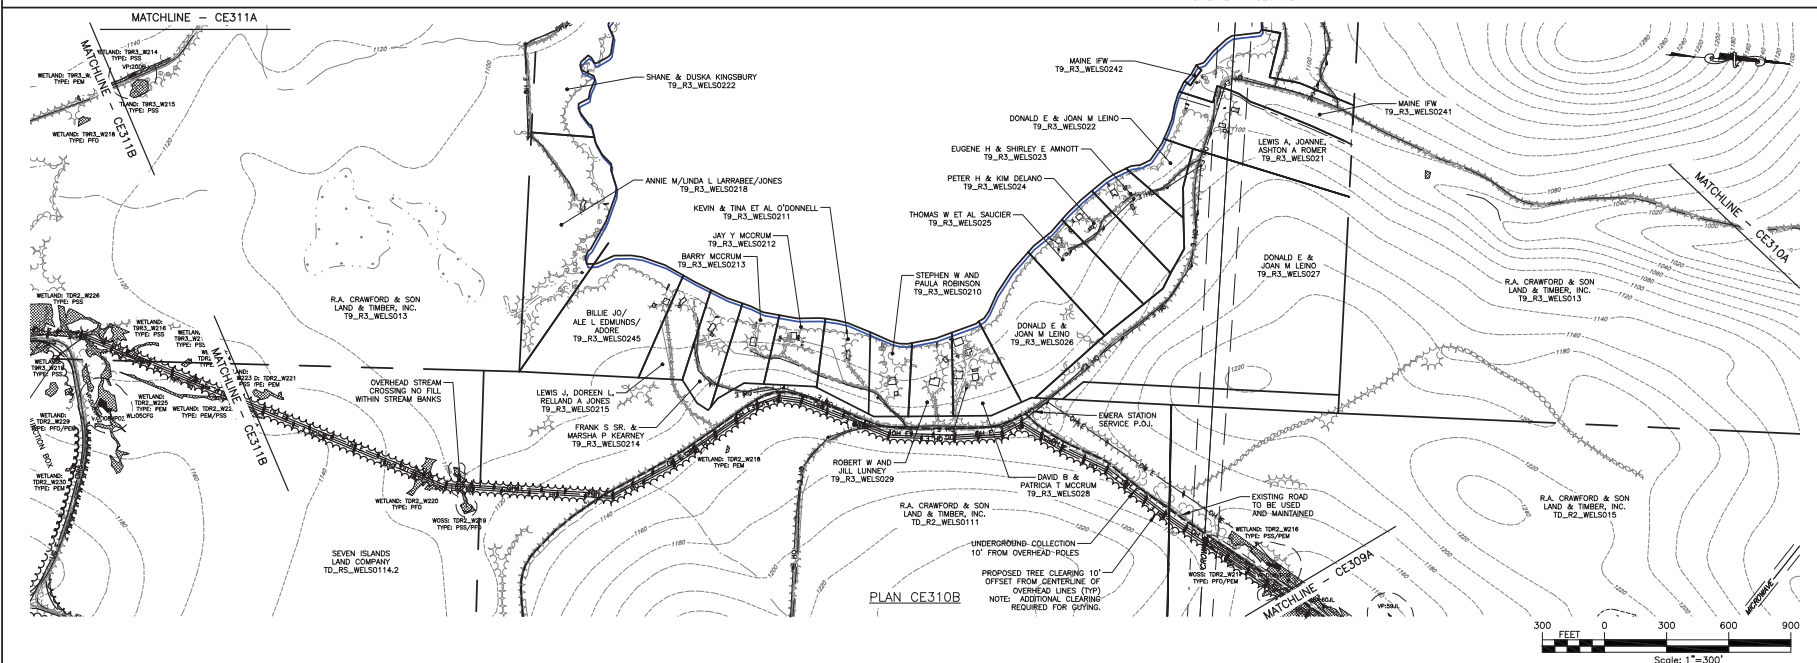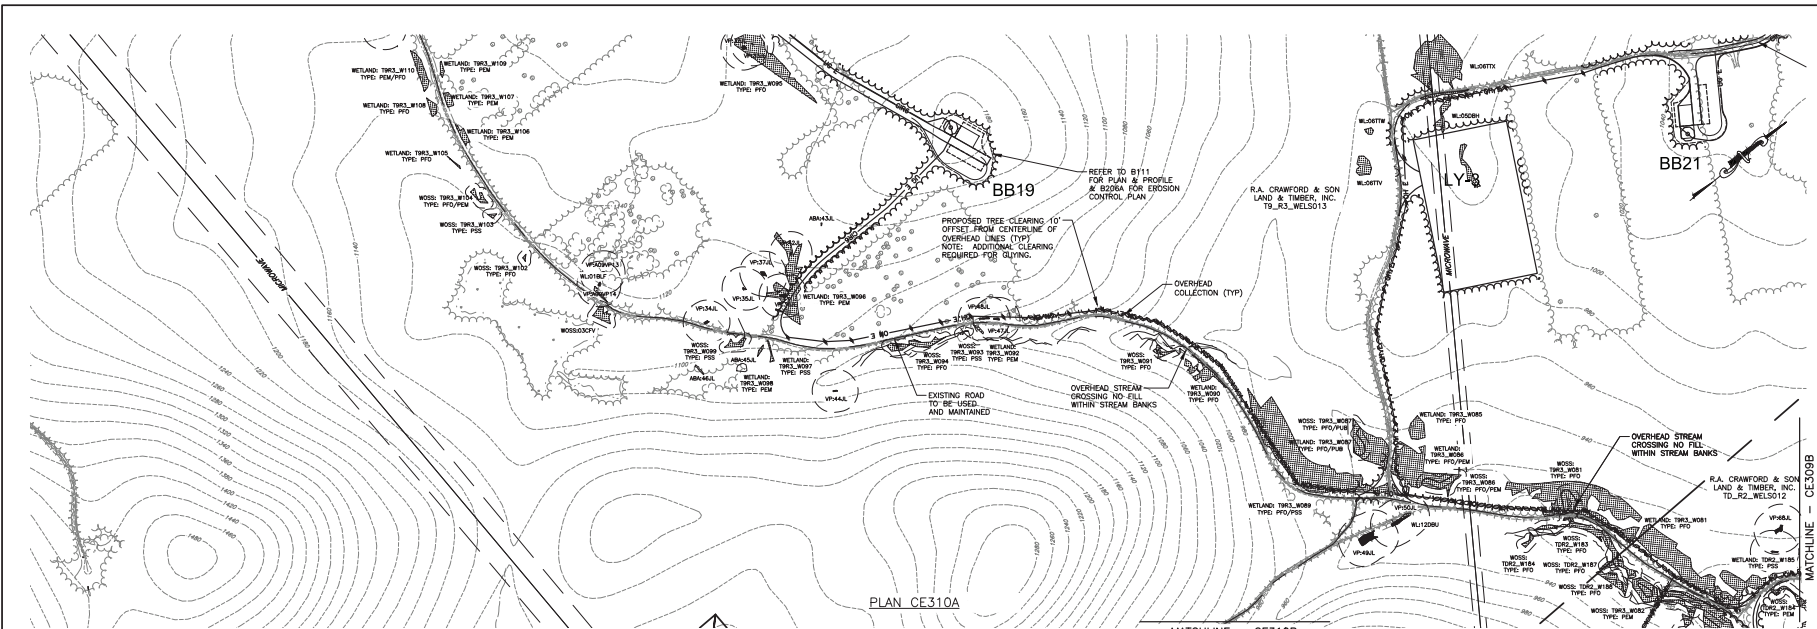

PROJECT		NUMBER NINE WIND FARM ARCOOSTOOK COUNTY, MAINE PRELIMINARY PLANS NOT FOR CONSTRUCTION	
DRAWING NO.		CE310	
TITLE OF DRAWING		COLLECTION LINE PLAN	
DESIGNER		FISHBEIN ASSOCIATES www.fishbein.com	
PROJECT MANAGER		S. MELLOTT	
DRAWN BY		BK	
CHECKED BY		AS SHOWN	
DATE		JULY 2018	
REV		1	
DESCRIPTION			
DATE			
BY			

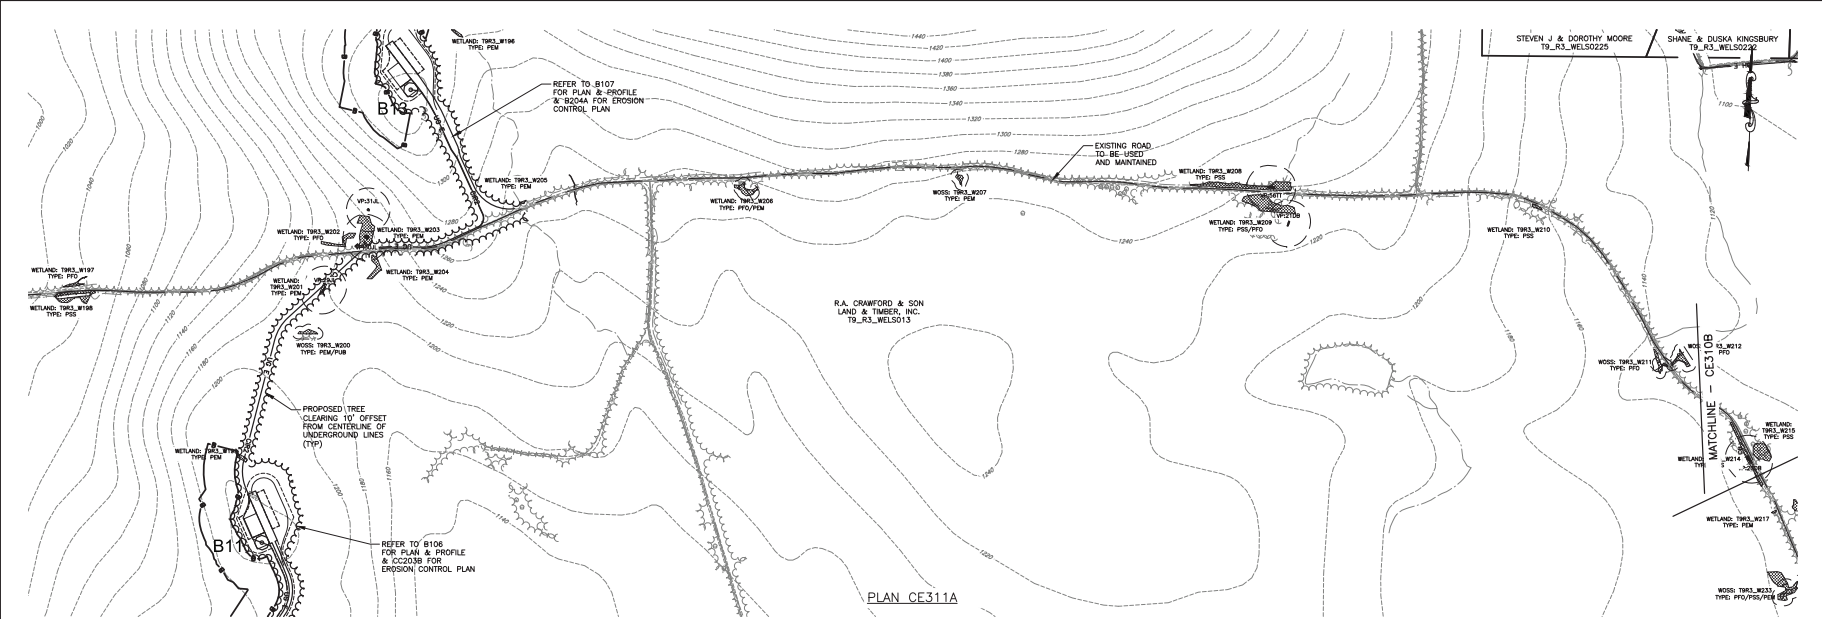

PLAN CE311A

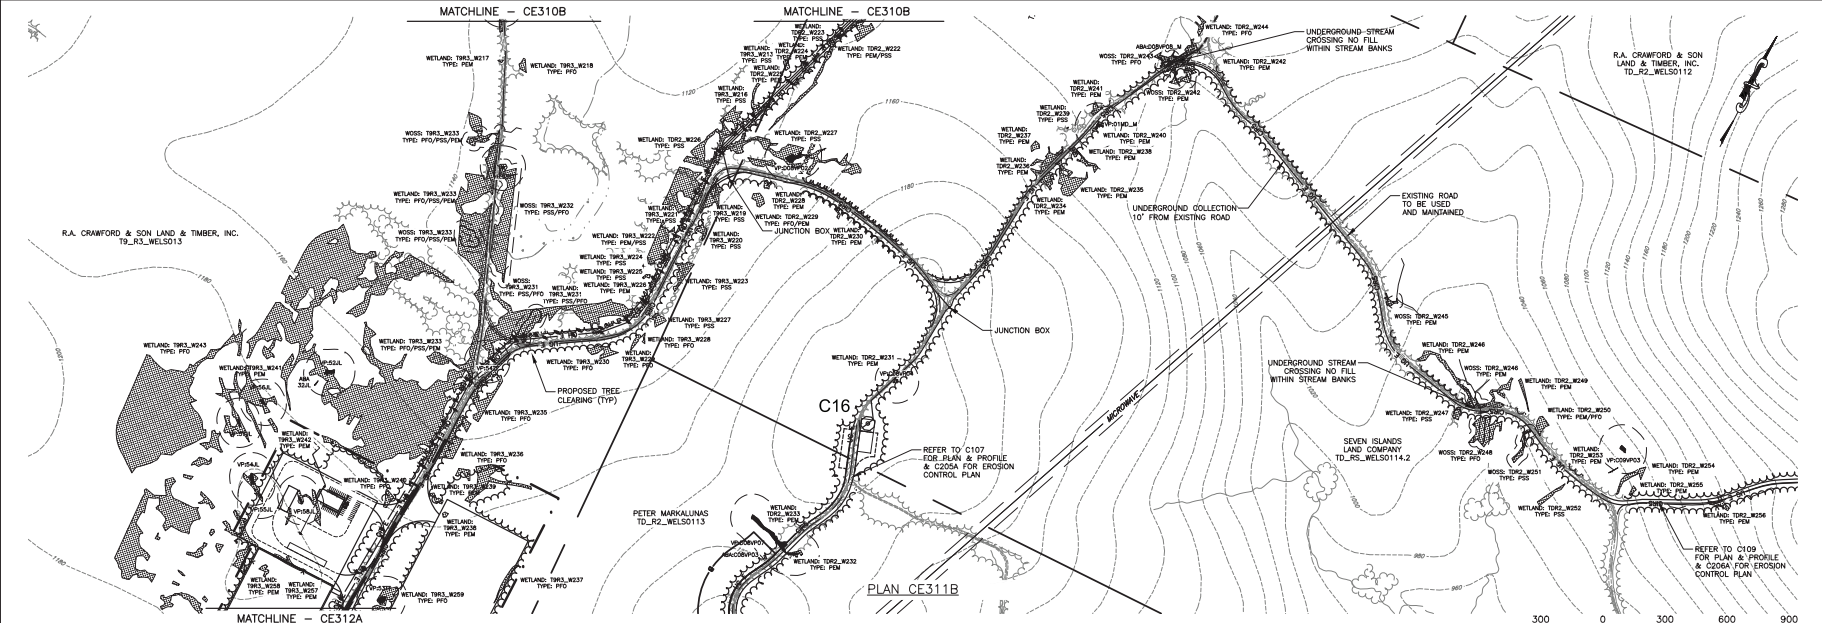


PLAN CE311B


FILE NAME: I:\Projects\140009\Plan_Prof\140009_Ce311A.dwg
 USER: Steven_Marletti
 DATE: 7/26/16

PROJECT NUMBER NINE WIND FARM ARCOOCHUCK COUNTY, MAINE PRELIMINARY PLANS NOT FOR CONSTRUCTION	DRAWING NO. CE311	SHEET 290 OF 338	TITLE OF DRAWING COLLECTION LINE PLAN	NUMBER NINE WIND FARM		DATE JULY 2016
						AS SHOWN
						REV
PREPARED BY S. MELLOTT	CHECKED BY BK	DATE JULY 2016	DESCRIPTION	DATE	BY	
7 6 5 4 3 2 1	140009	140009	COLLECTION LINE PLAN	JULY 2016	S. MELLOTT	

FILE NAME: I:\Projects\140009\Num_Nine_Main_LSA_Visual_GAD\CAD\140009_CE310-CE313_Sheets.dwg
 DATE PLOTTED: 7/26/17 10:40:12 AM
 USER: Steven Mardot

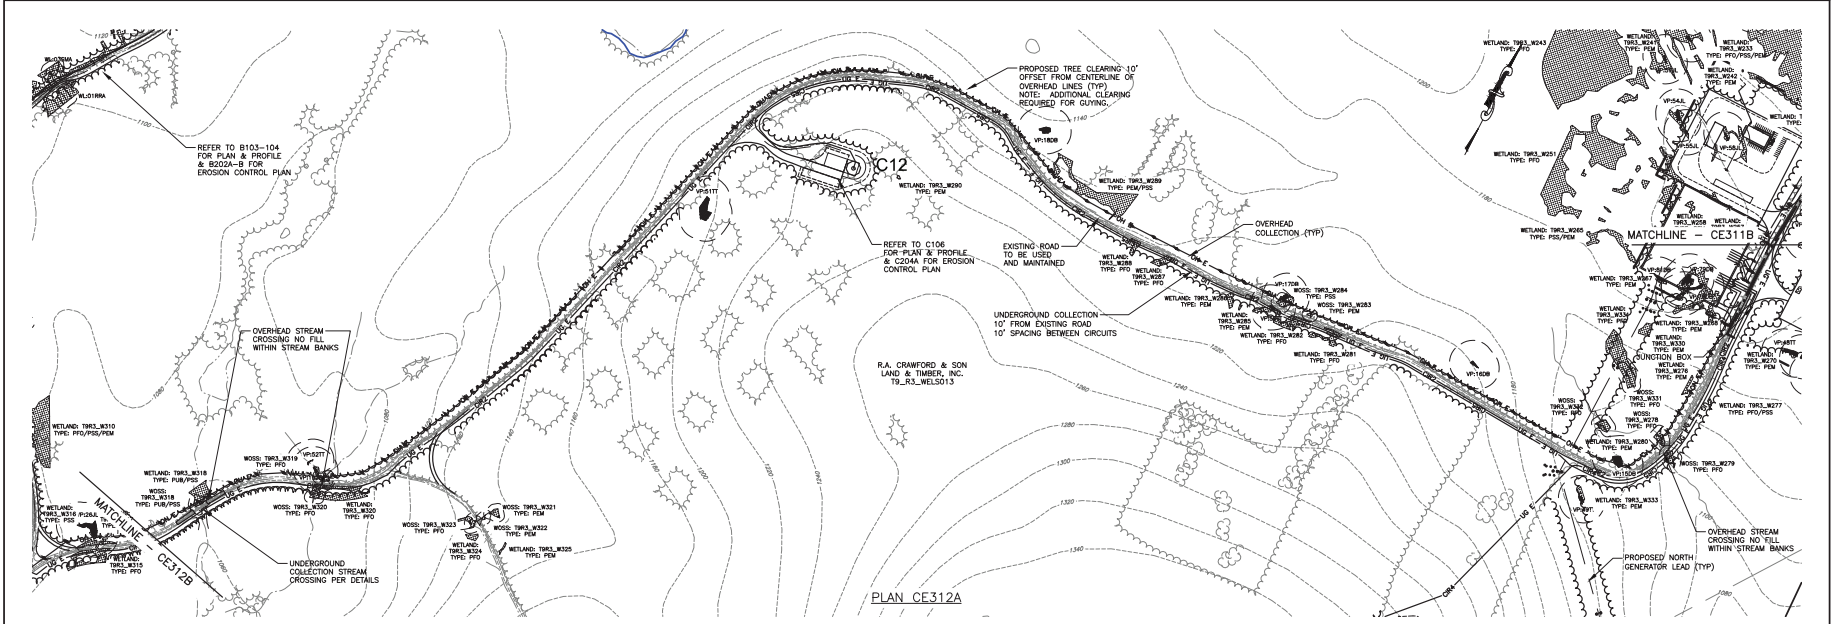

PLAN CE312A

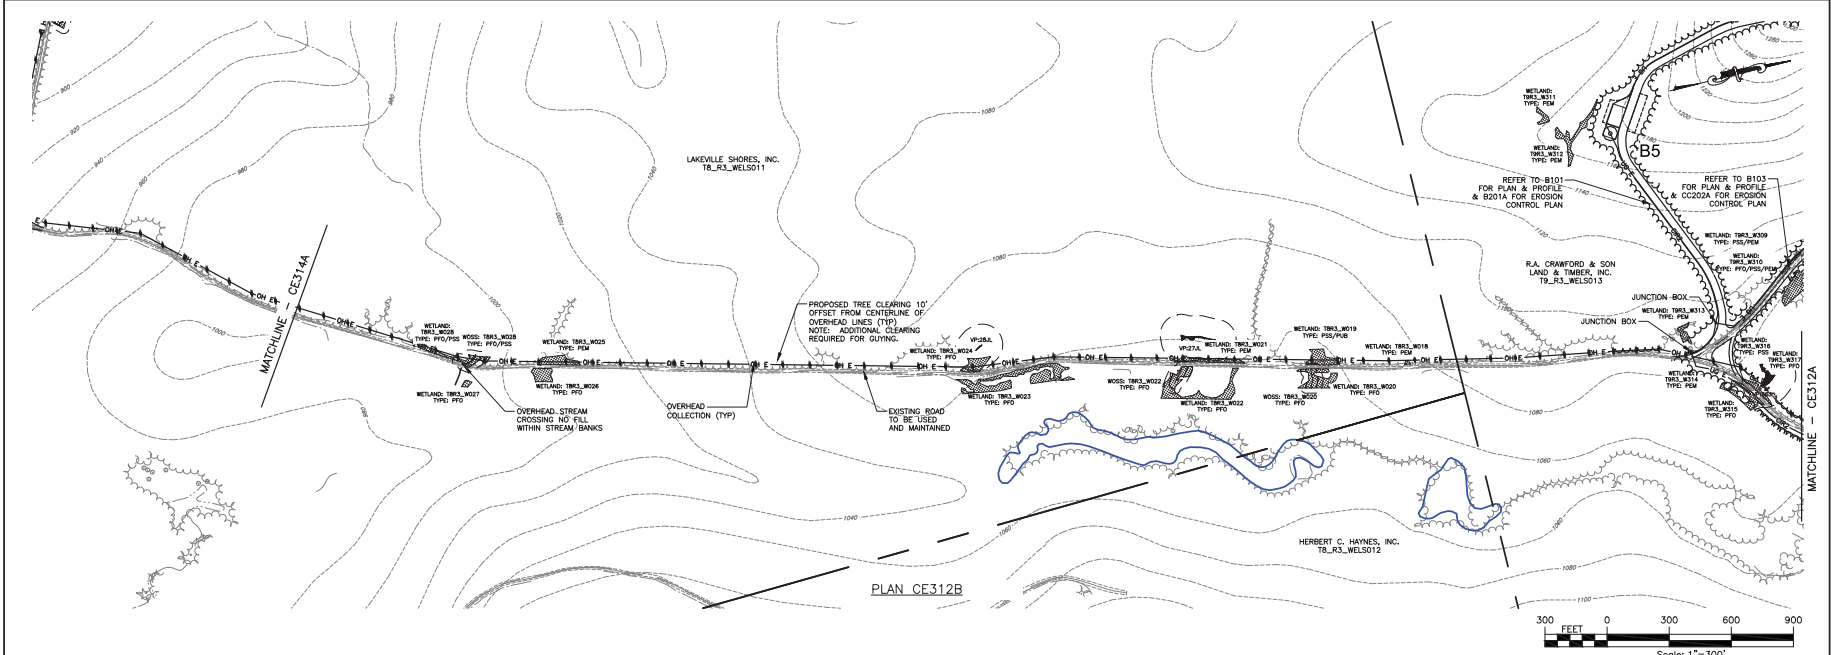

PLAN CE312B

7	REVISION	DATE	BY
6			
5			
4			
3			
2			
1			
REV	DESCRIPTION	DATE	BY


PROJECT: NUMBER NINE WIND FARM
 AROOSTOOK COUNTY, MAINE
 PRELIMINARY PLANS NOT FOR CONSTRUCTION
 TITLE OF DRAWING: COLLECTION LINE PLAN

DRAWING NO: **CE312**
 SHEET 291 OF 338

PROJECT MANAGER: S. MELLOTT
 CHECKED BY: BK
 DATE: JULY 2015
 AS SHOWN

FISHKILL CONSULTANTS
 www.fishkillconsultants.com

FILE NAME: I:\Projects\140009-Num_Nine_Wind_Form_LSA\DWG\CUT\140009_CE310-CE313_Sheets.dwg
 DATE: 7/10/16 PM
 USER: Steve Merrill

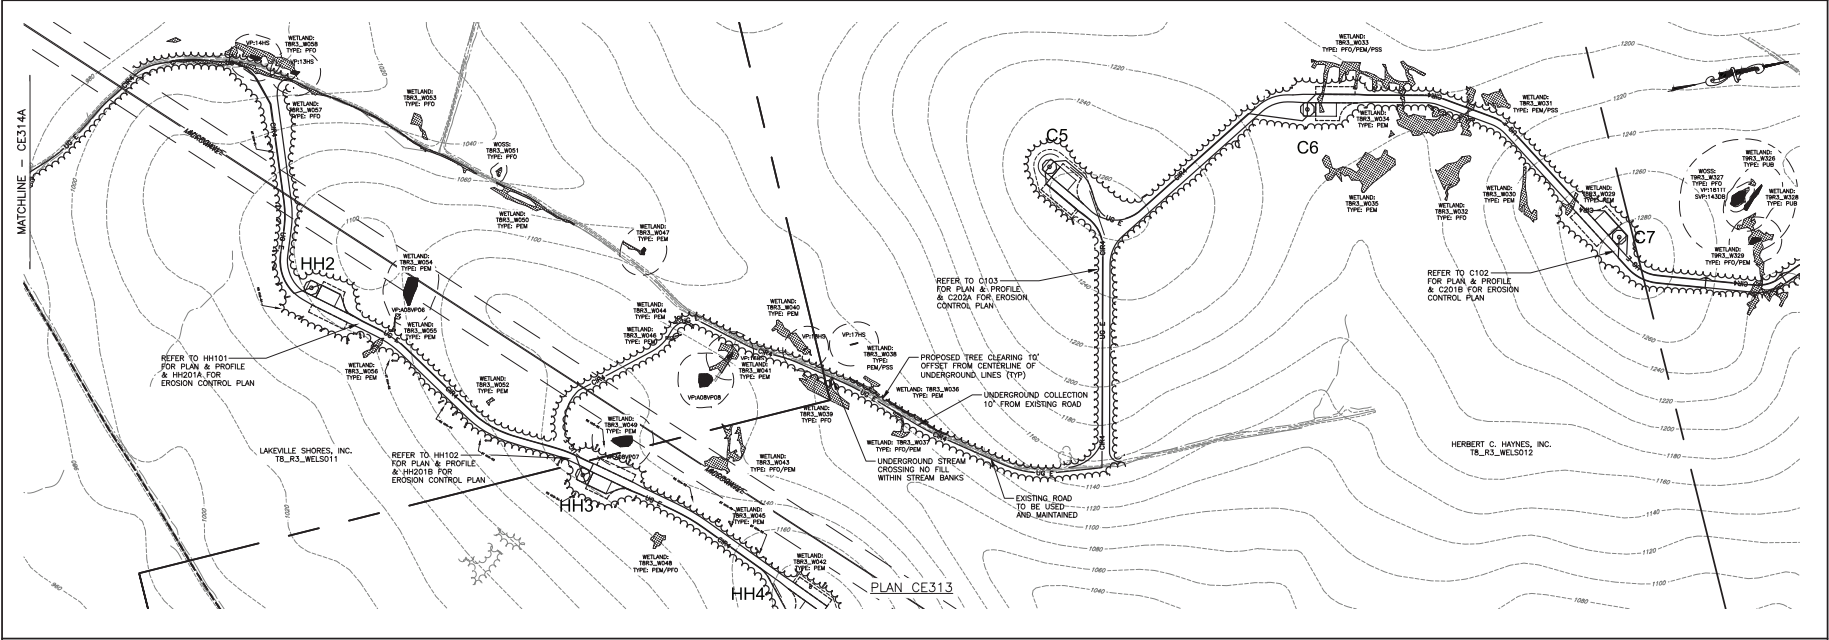


REVISION NO.	DESCRIPTION	DATE	BY
1			
2			
3			
4			
5			
6			
7			

PROJECT:
 NUMBER NINE WIND FARM
 AROOSTOOK COUNTY, MAINE
 PRELIMINARY PLANS NOT FOR CONSTRUCTION

TITLE OF DRAWING:
 COLLECTION LINE PLAN

9
 NUMBER NINE
 WIND FARM™




FISHER ASSOCIATES INC.
 ENGINEERS AND ARCHITECTS
 100 OAK STREET
 MAINE, U.S.A.


PROSPECTOR: 140009	CONTRACT NO.: CEN 14.001	DATE: JULY 2016
PROJECT MANAGER: S. MELLOTT	DESIGNER: S. MELLOTT	
CHECKER: BK	DATE: JULY 2016	
SCALE: AS SHOWN	DATE: JULY 2016	

DRAWING NO. CE313
 SHEET 292 OF 338

FILE NAME: I:\Projects\140009\Num_Nine_Mid_LSA.dwg (AO/CIV) 140009 CE314-CE317 Sheets.dwg
 USER: Steven Marlot
 DATE: 7/16/15 10:41:15 AM

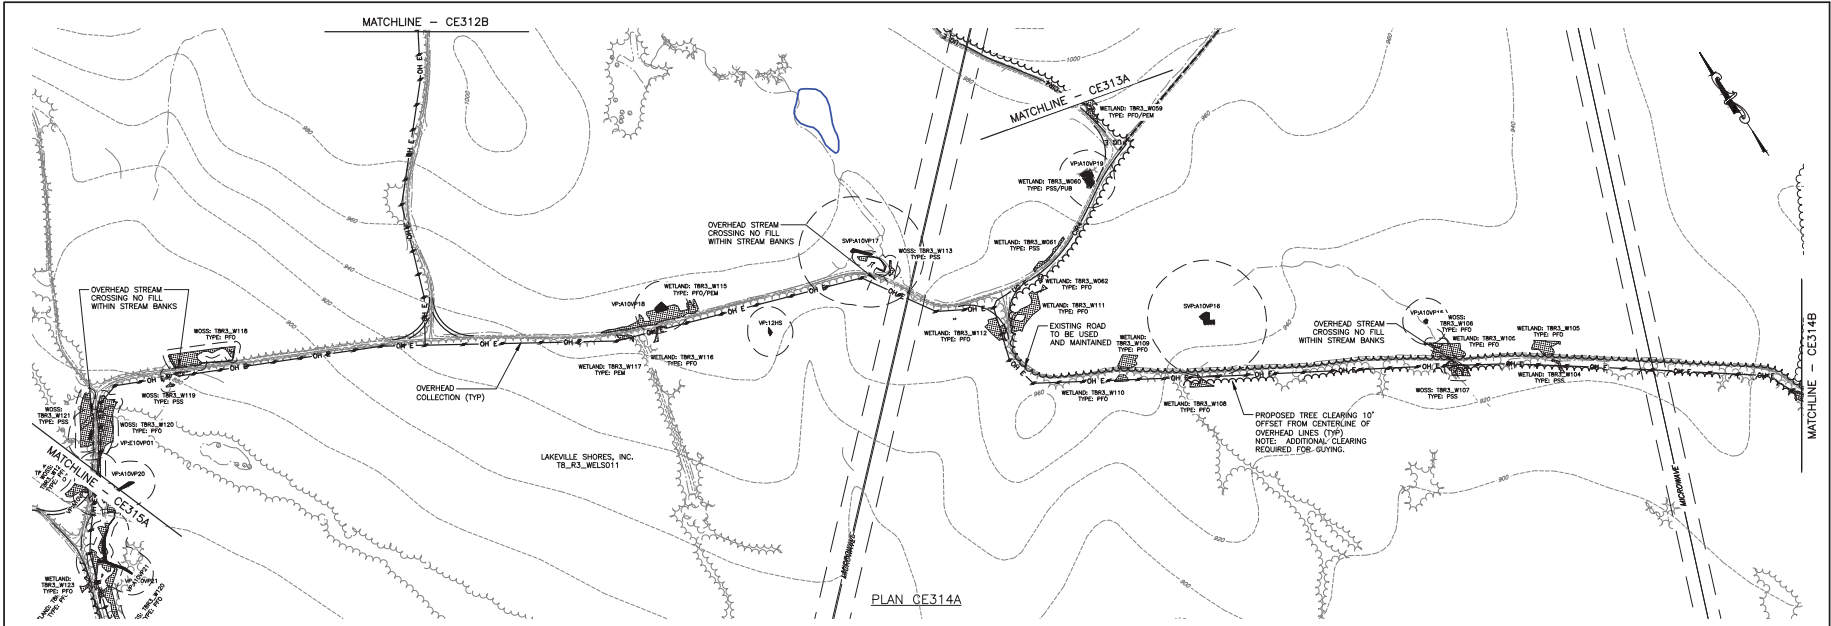


PLAN CE314A

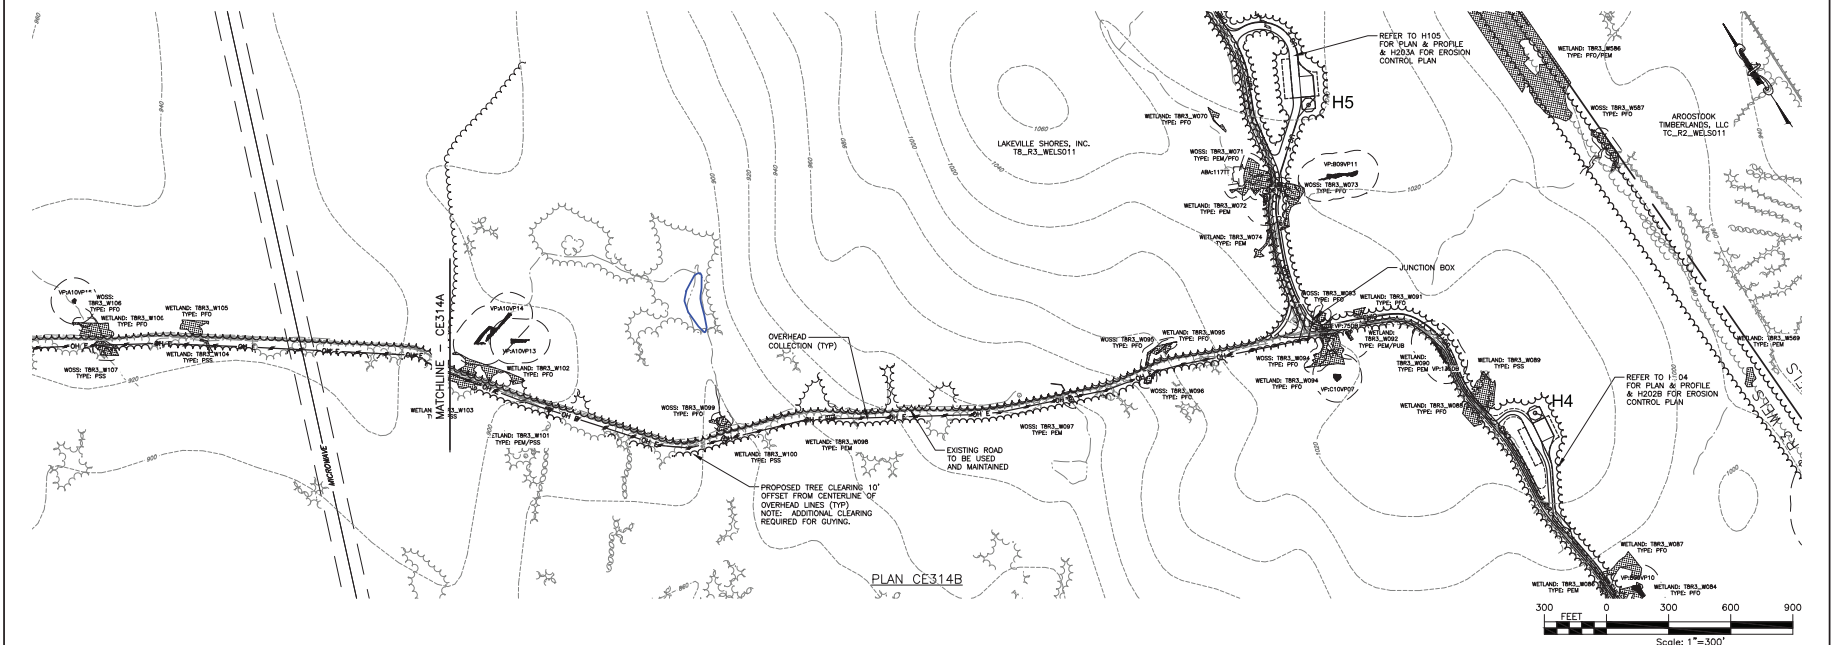


PLAN CE314B

PROJECT: NUMBER NINE WIND FARM AROOSTOOK COUNTY, MAINE PRELIMINARY PLANS NOT FOR CONSTRUCTION	DRAWING NO: CE314	SHEET 293 OF 338	TITLE OF DRAWING: COLLECTION LINE PLAN	NUMBER NINE WIND FARM		AS SHOWN	JULY 2015	REV	DESCRIPTION	DATE	BY	
						1	1	1	1	1	1	1
						2	2	2	2	2	2	2
						3	3	3	3	3	3	3
						4	4	4	4	4	4	4
						5	5	5	5	5	5	5
						6	6	6	6	6	6	6
7	7	7	7	7	7	7						


FILE NAME: I:\Projects\140009\Num_Nine_Main_LBA.dwg (A/C/G/C/U) 140009 CE314-CE317 Sheets.dwg
 USER: Steven Mardit
 DATE: 7/16/2018 PM

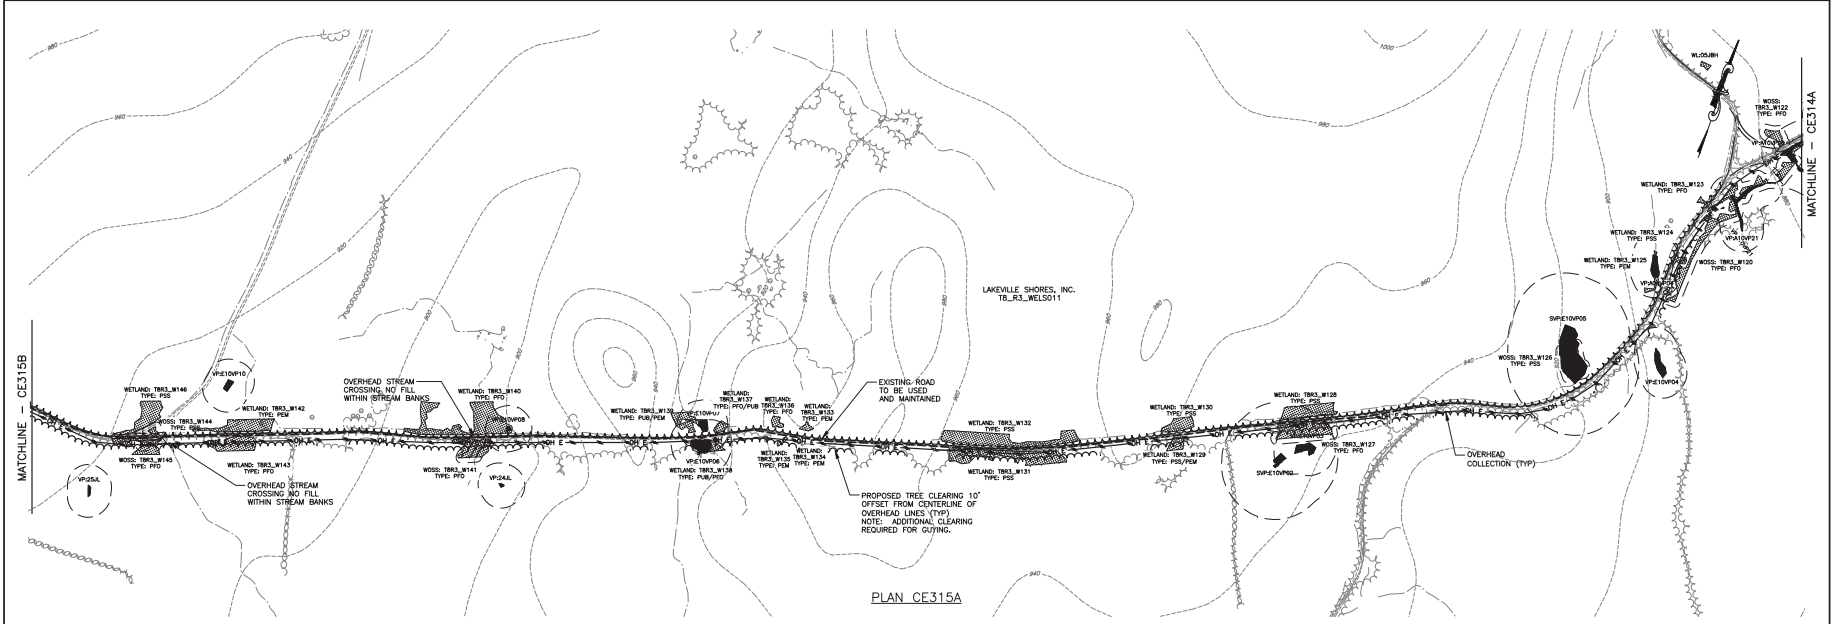

PLAN CE315A

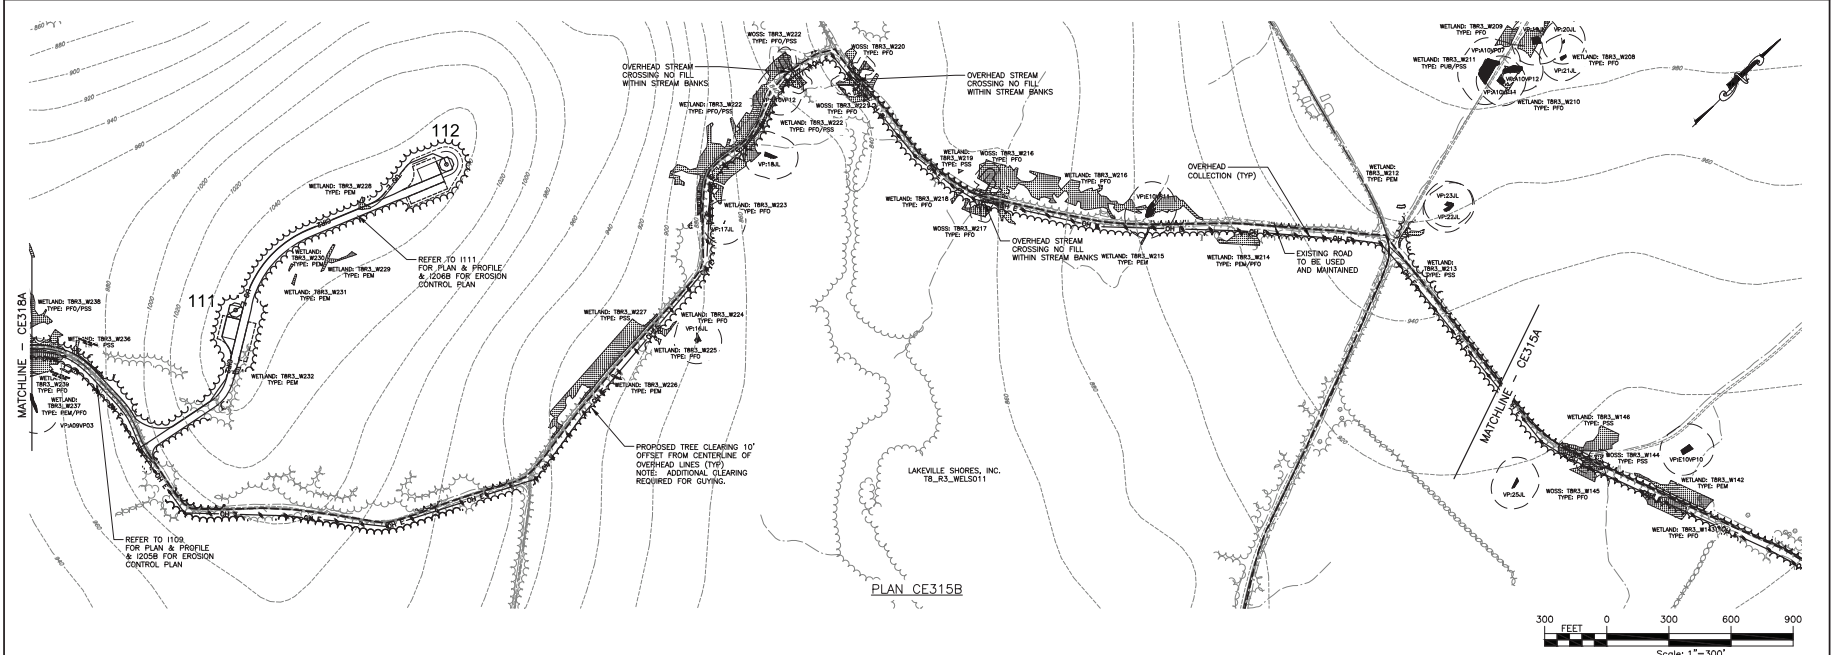

PLAN CE315B

 

MATCHLINE - CE314A

REV	DESCRIPTION	DATE	BY
7			
6			
5			
4			
3			
2			
1			

CONTRACT NO. 2014 PROJECT NO. 140009 PROJECT MANAGER S. MELLOTT EXAMINER BK SCALE AS SHOWN SHEET NO. JULY 2018	CONTRACTOR'S DESIGN PREPARED BY: S. MELLOTT CHECKED BY: S. MELLOTT DATE: 7/16/2018 PROJECT NO. 140009 SHEET NO. CE315B TOTAL SHEETS: 3
---	--

 


140009
 S. MELLOTT
 BK
 JULY 2018



PROJECT: NUMBER NINE WIND FARM
 AROOSTOOK COUNTY, MAINE
 PRELIMINARY PLANS NOT FOR CONSTRUCTION
 NUMBER NINE WIND FARM
 TITLE OF DRAWING: COLLECTION LINE PLAN

DRAWING NO.
CE315
 SHEET 294 OF 338

FILE NAME: I:\Projects\140009\Num_Nine_Main_LSA_Veg_CAD\CAD\140009_CE31A-CE317_Sheets.dwg
 DATE: 7/16/16 PM
 USER: Steven Marlot

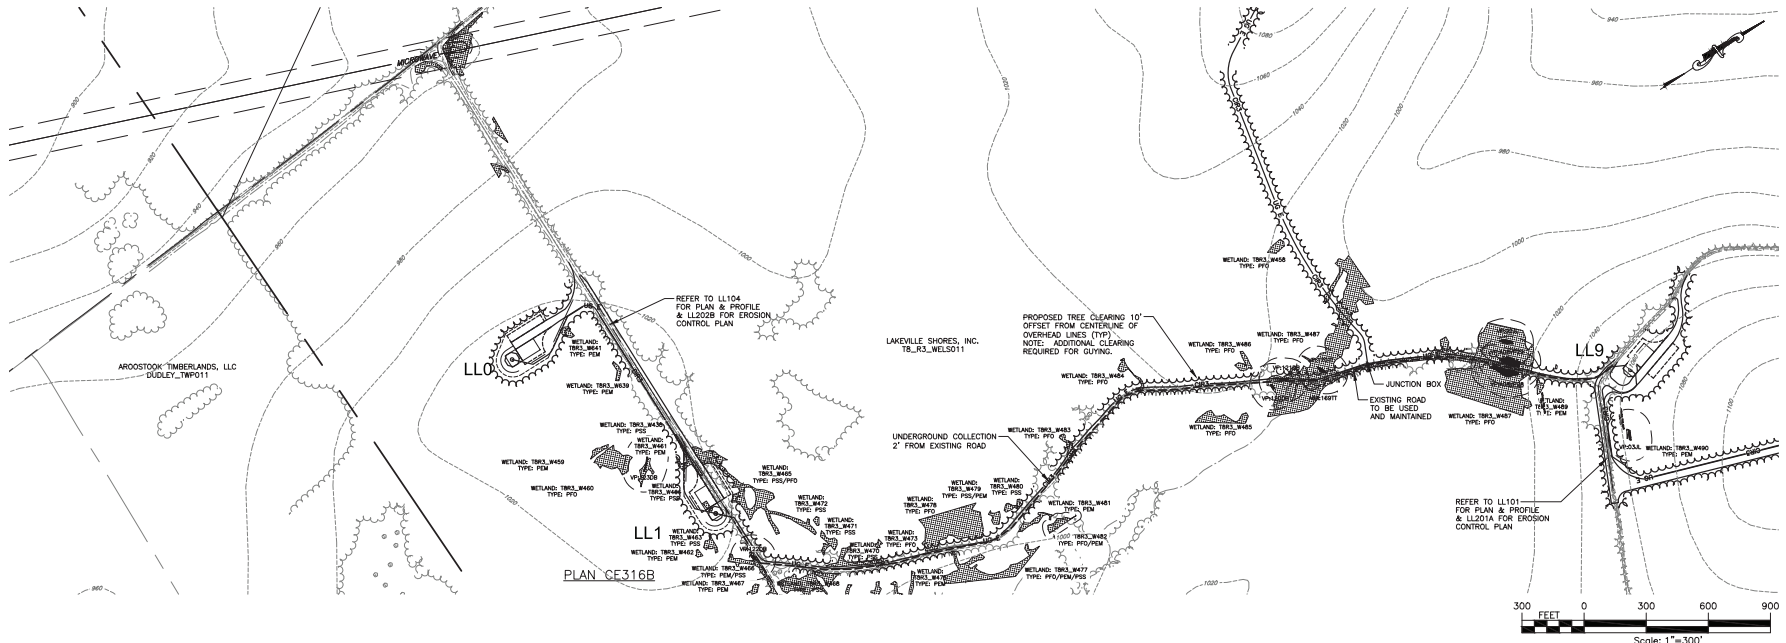
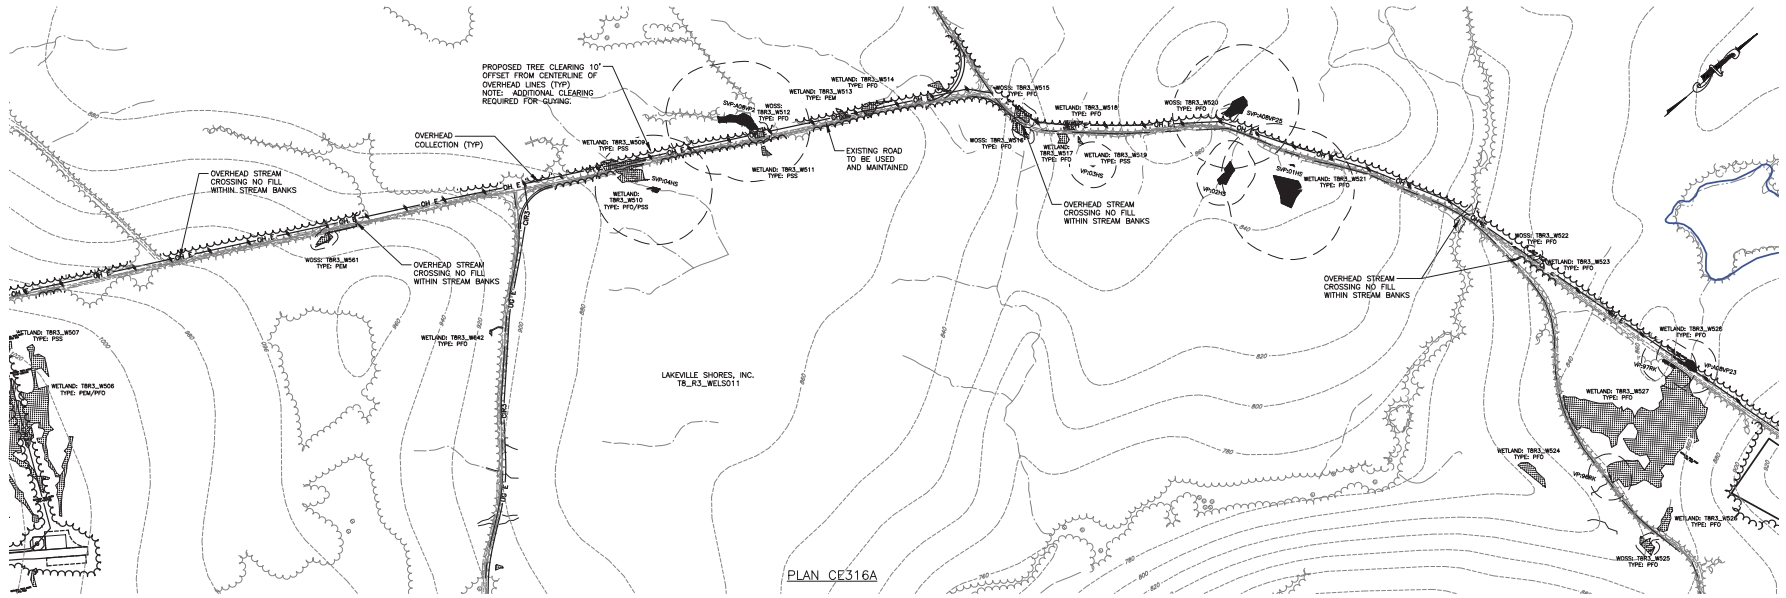


DRAWING NO.		CE316	
PROJECT		NUMBER NINE WIND FARM ARROSTOOK COUNTY, MAINE PRELIMINARY PLANS NOT FOR CONSTRUCTION	
DESIGNER		PROJECT MANAGER	
S. MELLOTT		S. MELLOTT	
CHECKED BY		DATE	
BK		JULY 2016	
AS SHOWN		REV	
DESCRIPTION		DATE	
COLLECTION LINE PLAN		BY	
TITLE OF DRAWING		REV	
NUMBER NINE WIND FARM		1	
WIND FARM		2	
1		3	
2		4	
3		5	
4		6	
5		7	



PROJECT: NUMBER NINE WIND FARM
 ARROSTOOK COUNTY, MAINE
 PRELIMINARY PLANS NOT FOR CONSTRUCTION

FILE NAME: I:\Projects\140009\Num_Nine_Wind_Farm_LSA_V01.dwg (A0/CUT) 140009_CE317-CE317_Sheets.dwg
 DATE: 7/2/2016 10:42:08 AM
 USER: Steve Martini

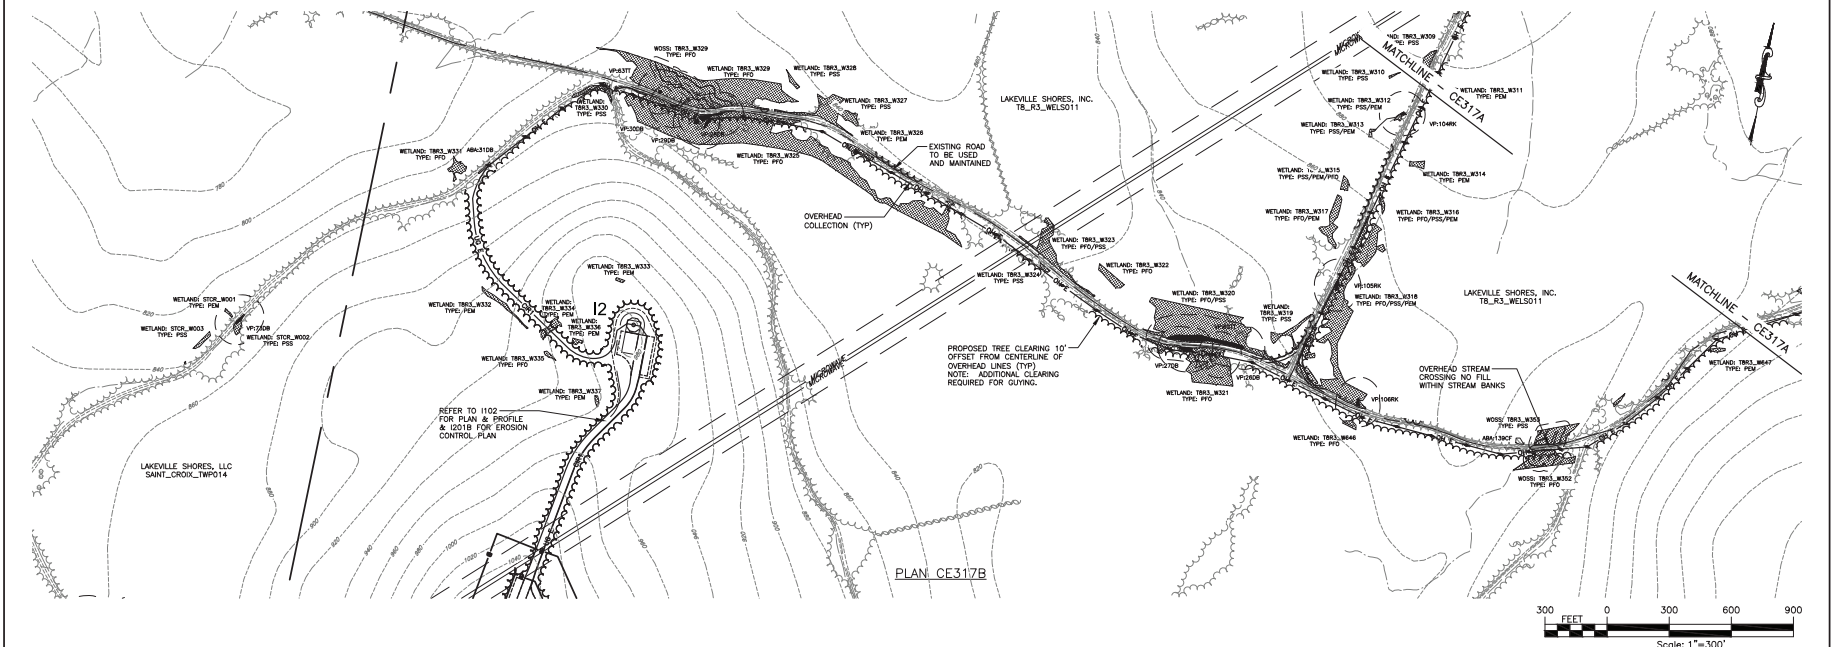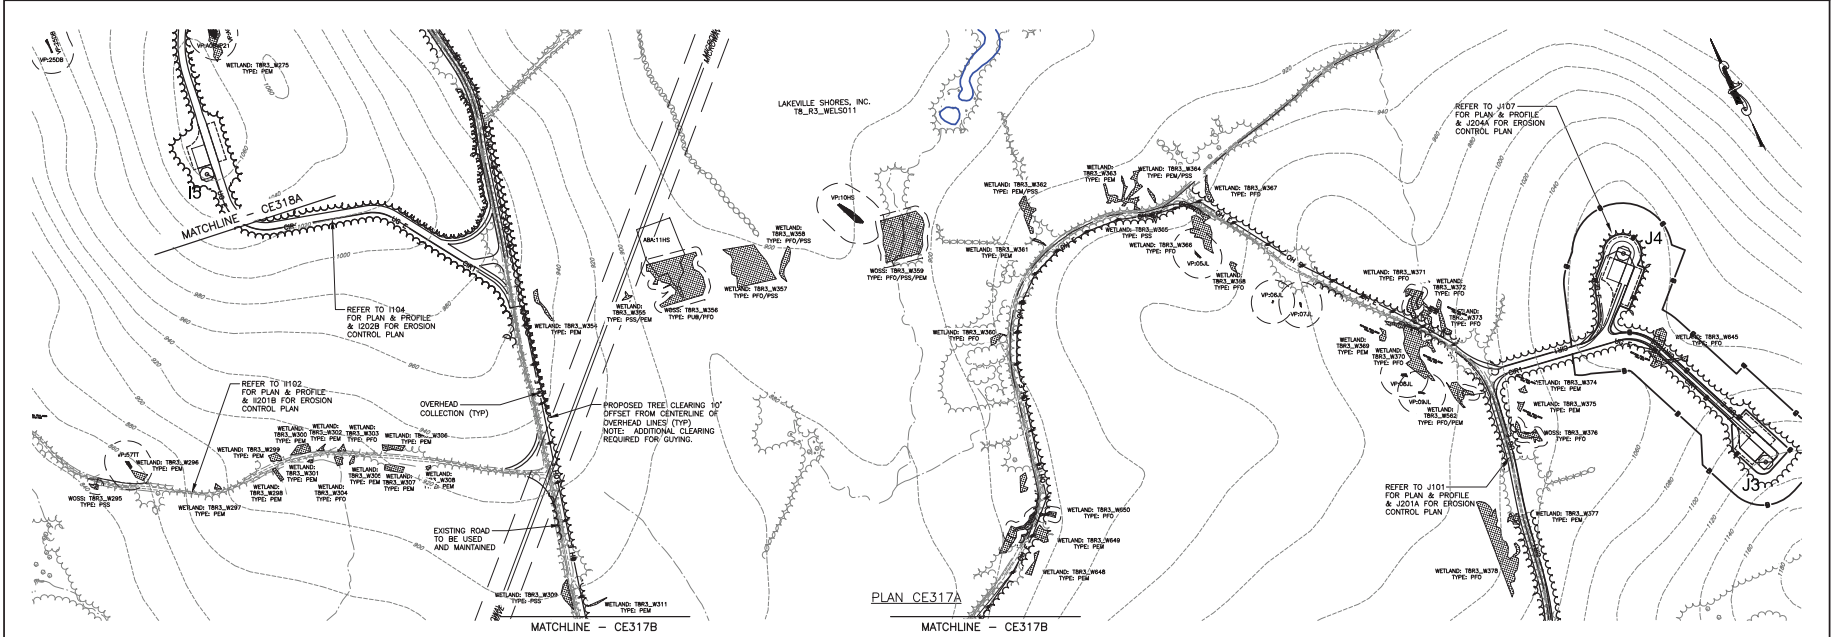

PROJECT		DRAWING NO.	
NUMBER NINE WIND FARM ARROSTOCK COUNTY, MAINE PRELIMINARY PLANS NOT FOR CONSTRUCTION		CE317	
TITLE OF DRAWING		SHEET 296 OF 338	
COLLECTION LINE PLAN			
PROJECT MANAGER S. MELLOTT CHECKED BY BK DATE JULY 2016		AS SHOWN JULY 2016	
CONTRACT NO. 14-0009 DRAWING NO. 140009 SHEET NO. 296 OF 338		DATE JULY 2016	
PREPARED BY: S. MELLOTT CHECKED BY: BK DATE: JULY 2016		REV 1 2 3 4 5 6 7	
DESCRIPTION 1. AS SHOWN 2. AS SHOWN 3. AS SHOWN 4. AS SHOWN 5. AS SHOWN 6. AS SHOWN 7. AS SHOWN		DATE BY	

FILE NAME: I:\Projects\140009\Num_Nine_Wind_Farm_LSA_V09\CAD\CAD\140009_CE318_Sheets.dwg
 DATE: 07/26/16 09:26:42 AM
 USER: Steven Marlot

